

SFO

San Francisco  
International  
Airport

# AirTrain Extension and Improvements Program



Lot DD Station

SFAC – Civic Design Review, Phase 3

May 21, 2018





SFO Parking

AirTrain  
Station





curtain wall & louvers



boarding area



pedestrian bridge




## Exterior Envelope



Aluminum Louvers – Lot DD Station



Solarban 70 - Pedestrian Bridge  
With Silver Frit gradient pattern at platform

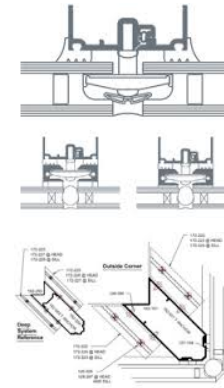

Aluminum Cladding – Lot DD Skirt



Guideway Concrete – New




Fall Protection

# LTP Station – Materials




San Francisco  
International  
Airport

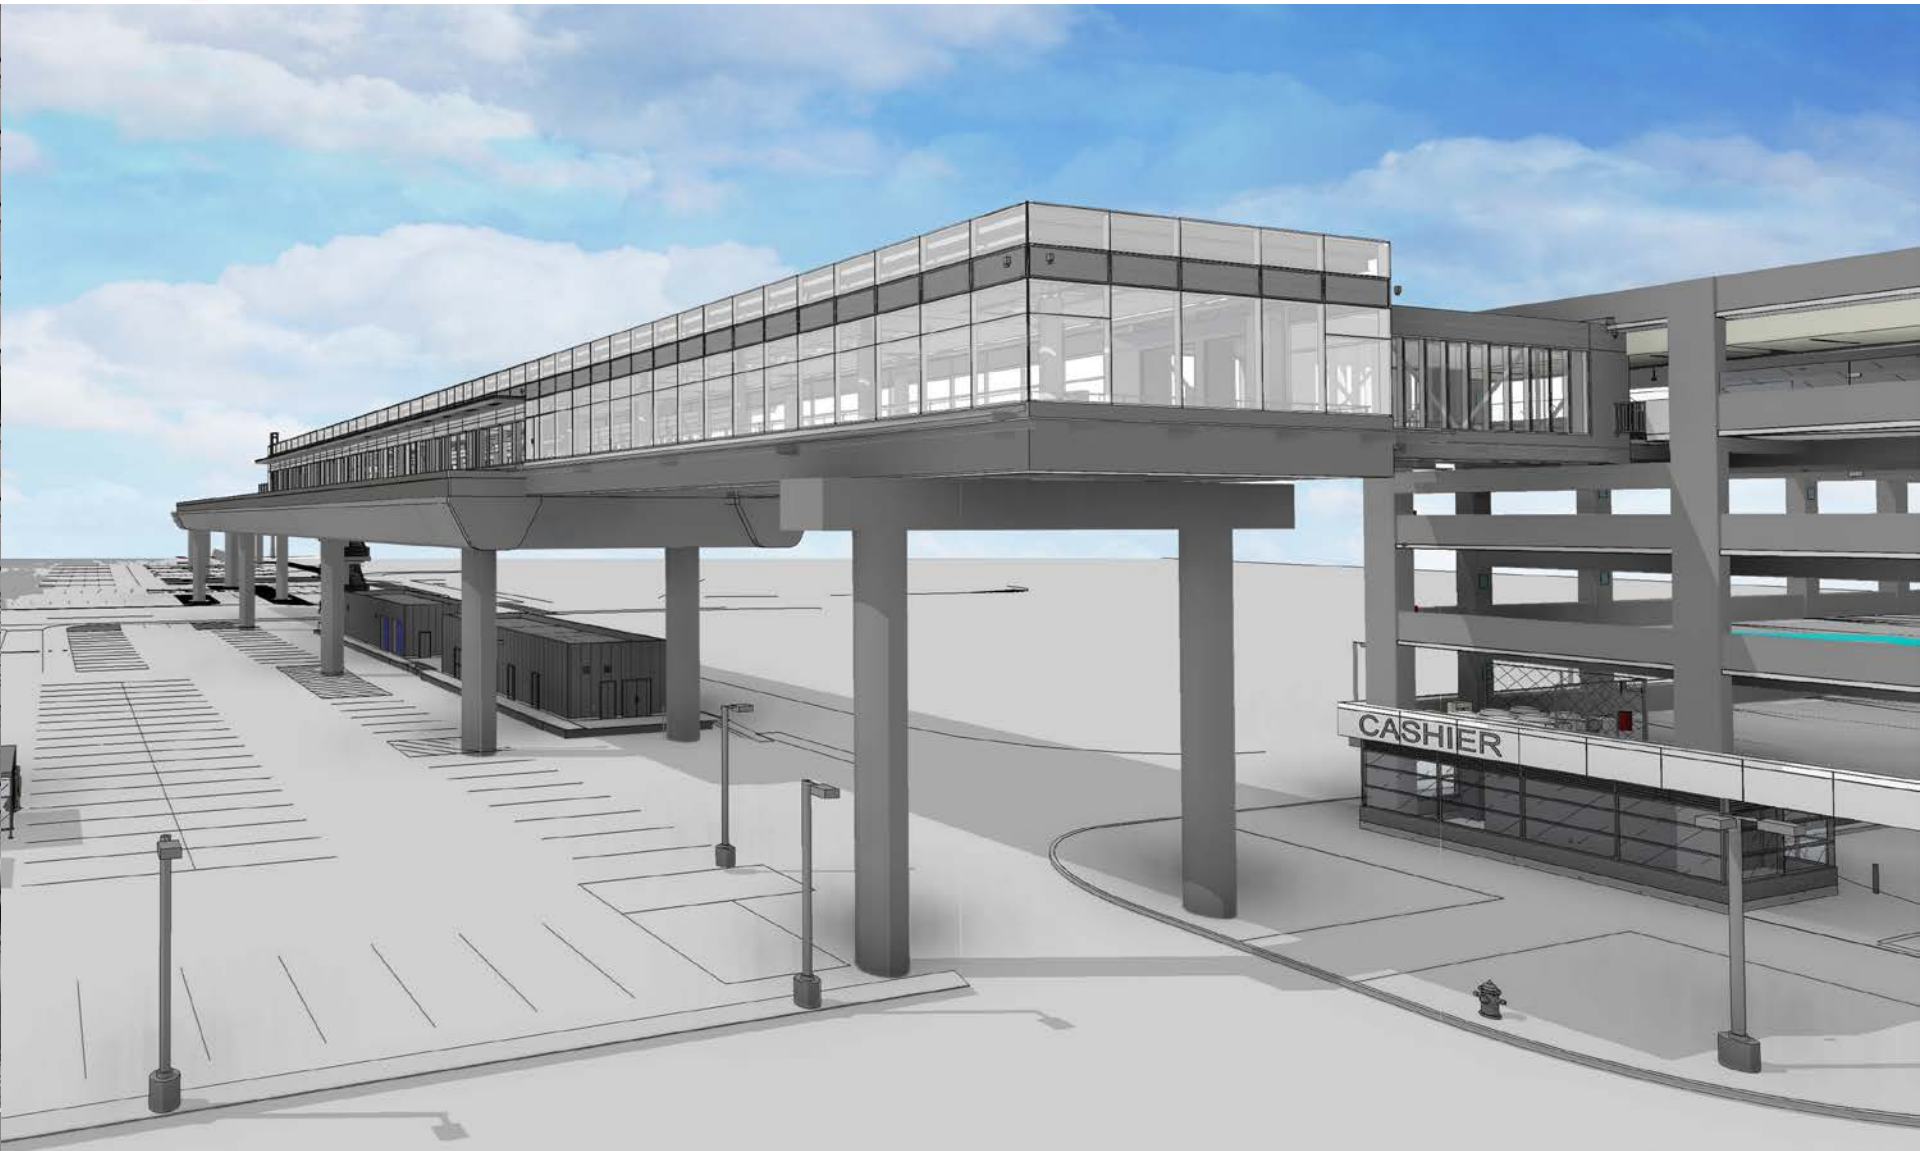

Site - Parking Entrance



San Francisco  
International  
Airport

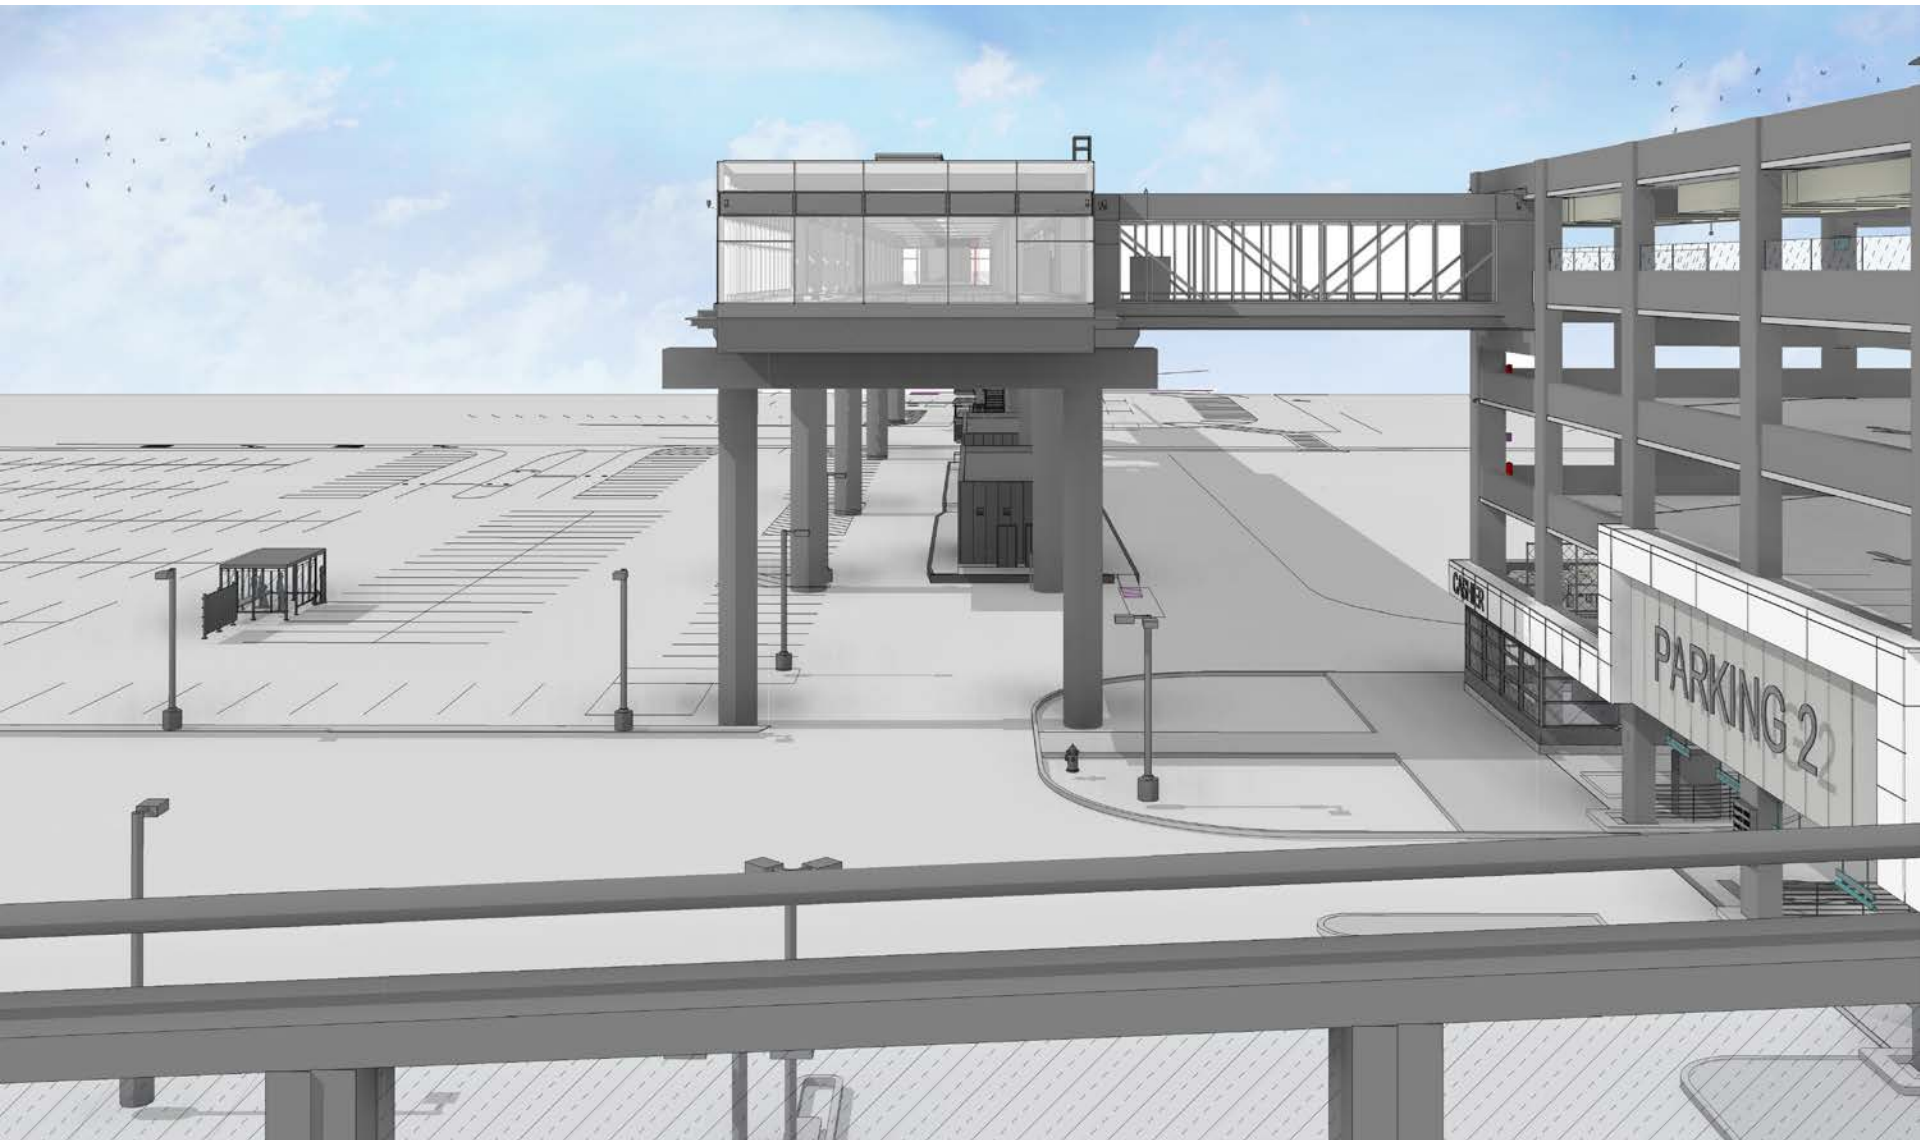

View South - From Garage Pedestrian Bridge

Updated to reflect 100% CDs





San Francisco  
International  
Airport



View West from N McDonnell Rd




San Francisco  
International  
Airport



West Station Exterior

Updated to reflect 100% CDs




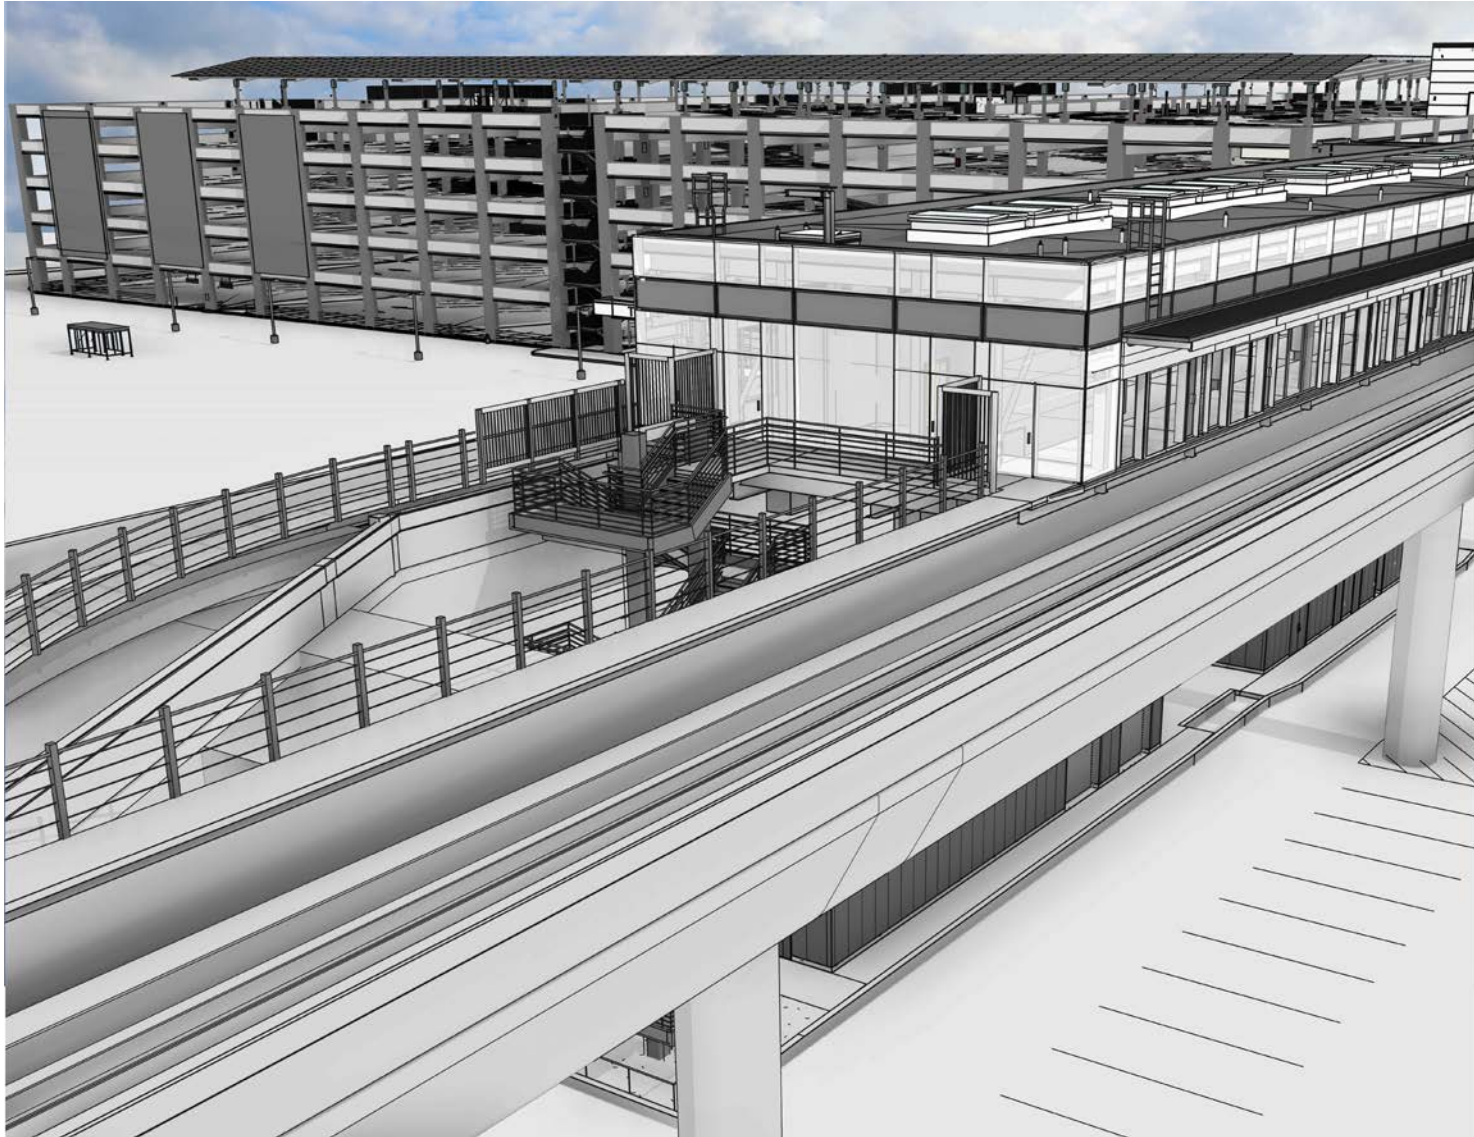

South End of Platform







San Francisco  
International  
Airport

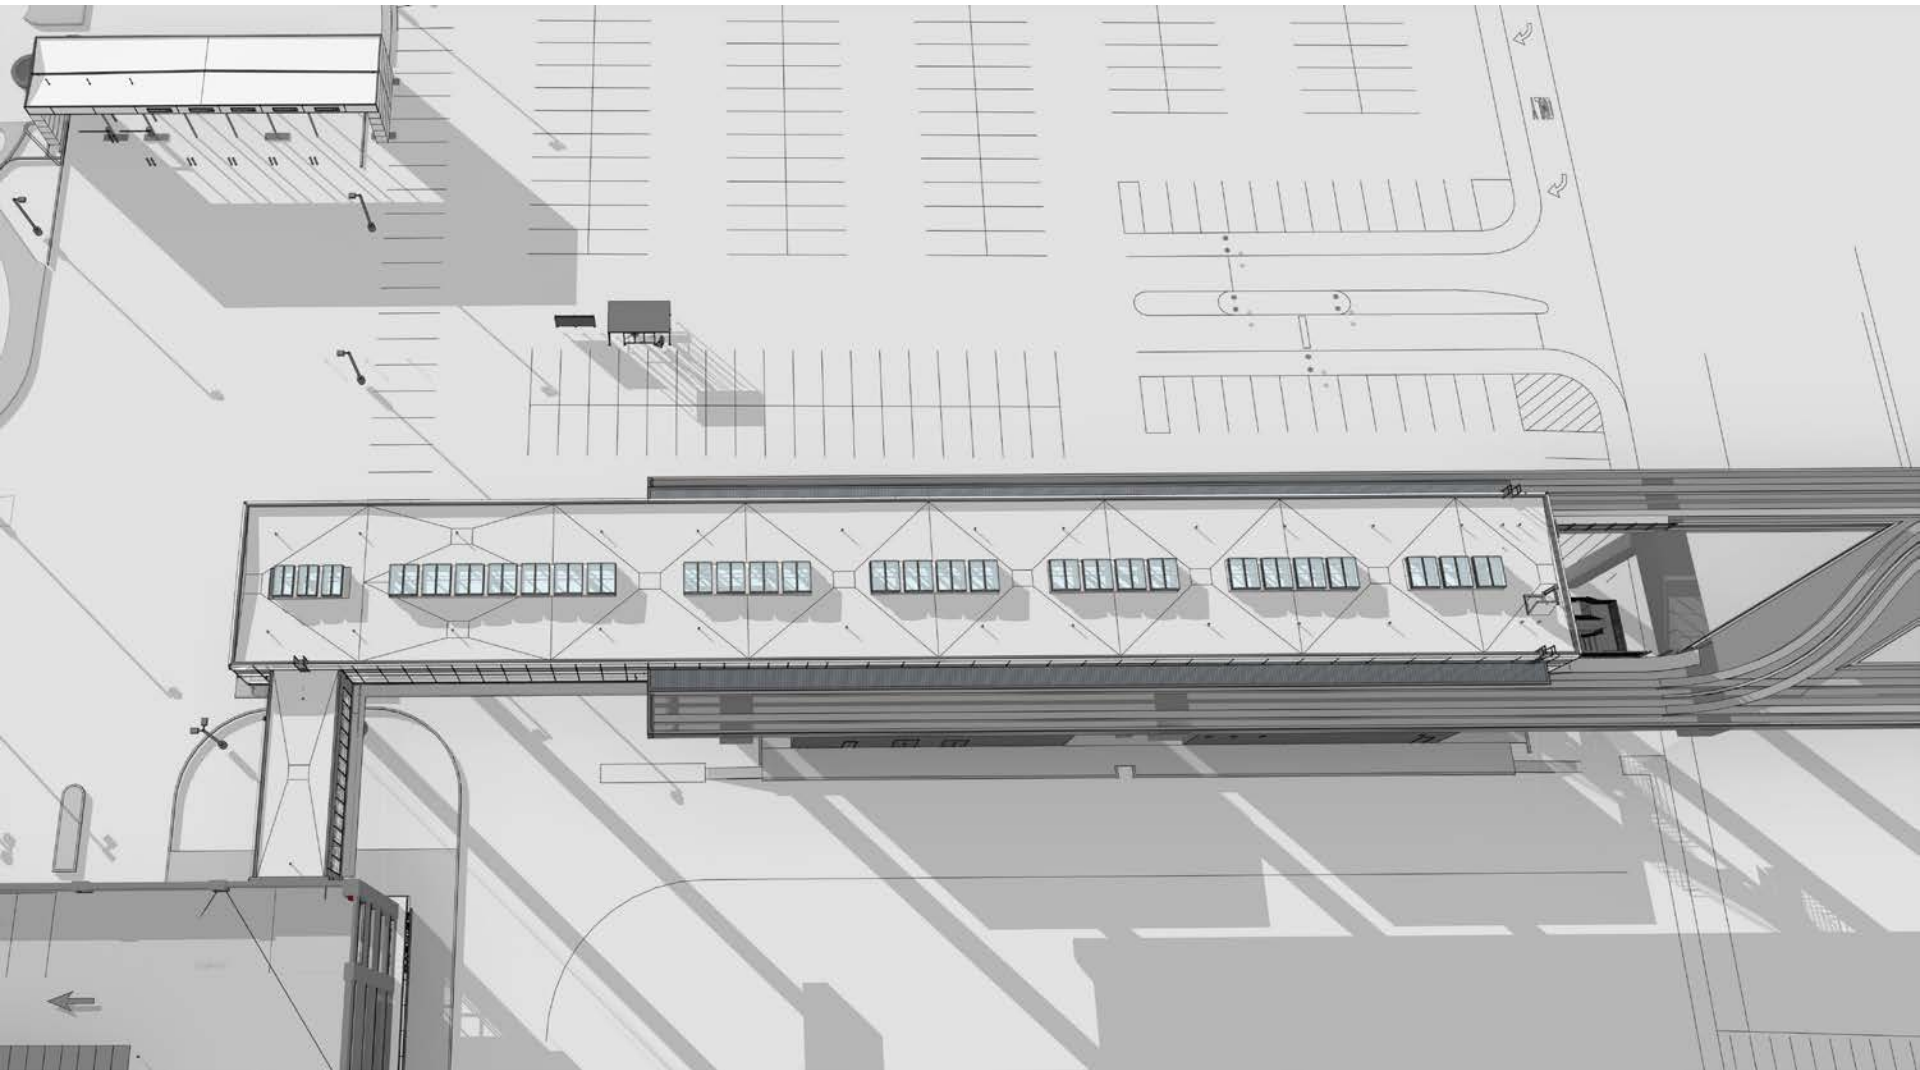



San Francisco International Airport

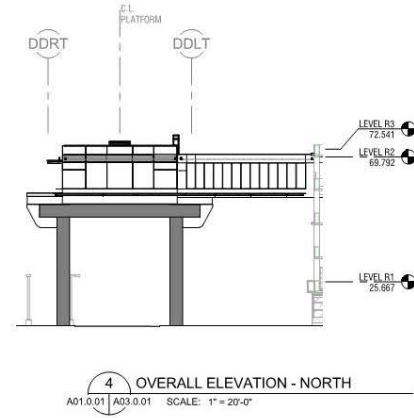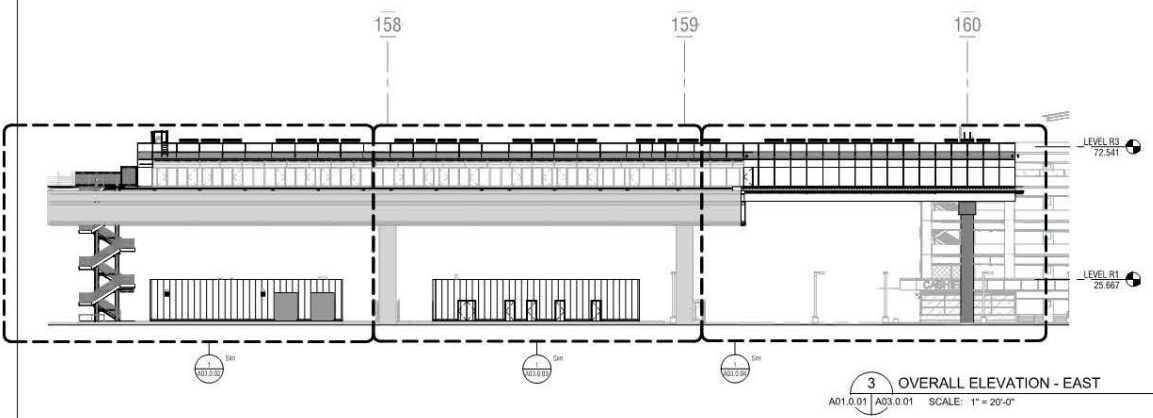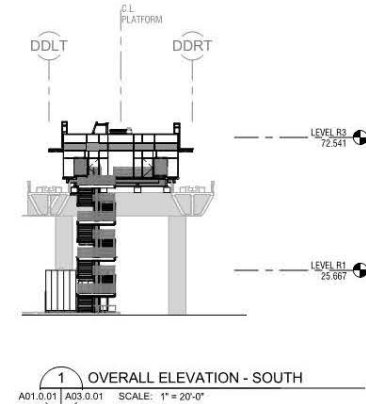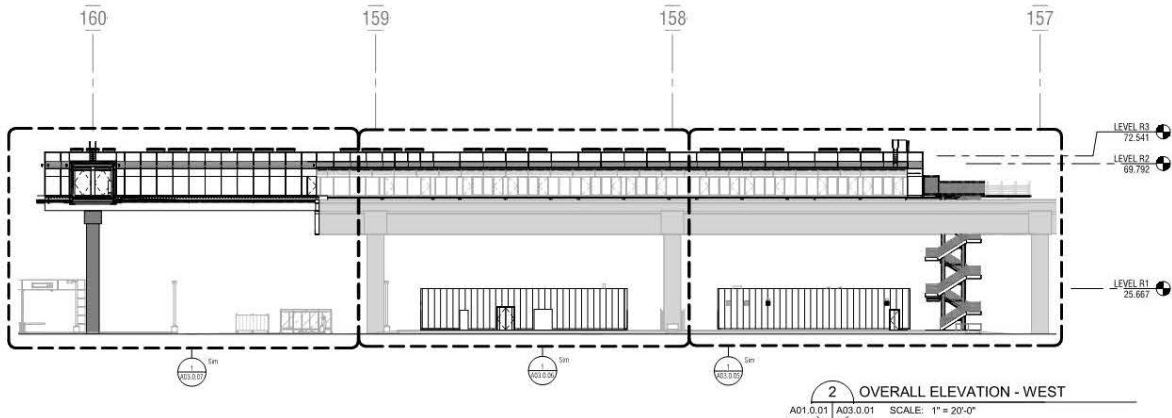

San Francisco International Airport

**SKANSKA** 1999 Harrison St. #1900  
Oakland, CA 94612  
skanska.com

**isp** 415 Market St.  
17th Fl.  
San Francisco, CA 94105  
isp.com

**rc** Robin Crispy & Company  
381 Valencia Street  
San Francisco, CA 94103  
(415) 895-8878

NO.	DATE	REVISIONS

10504.66

PROJECT TITLE  
**SFO AIRTRAIN EXTENSION AND IMPROVEMENTS PROGRAM**

SHEET TITLE  
**LOT DD STATION OVERALL EXTERIOR ELEVATIONS**




APPROVED:	APPROVED:
APPROVED:	APPROVED:
DESIGNED BY: R. CHAN	CHECKED BY: J. ANGLIM
DRAWN BY: M. REEVES	DATE: MARCH 23, 2018
SCALE: AS NOTED	SUR. REGION: ANSI-0
SHEET NUMBER: 797-A03.0.01	

Copyright © 2014-2015 City And County Of San Francisco. These construction documents are the sole property of The City And County Of San Francisco and are protected by the Copyright Act. Any reproduction, publication, or use by any method, in whole or in part, without the express written consent of the San Francisco Airport Commission is prohibited.

If this drawing is not ANSI D (34x42) NOMINAL SIZE, it has been revised from its original size and scales noted are no longer applicable.

100% CONSTRUCTION DOCUMENTS



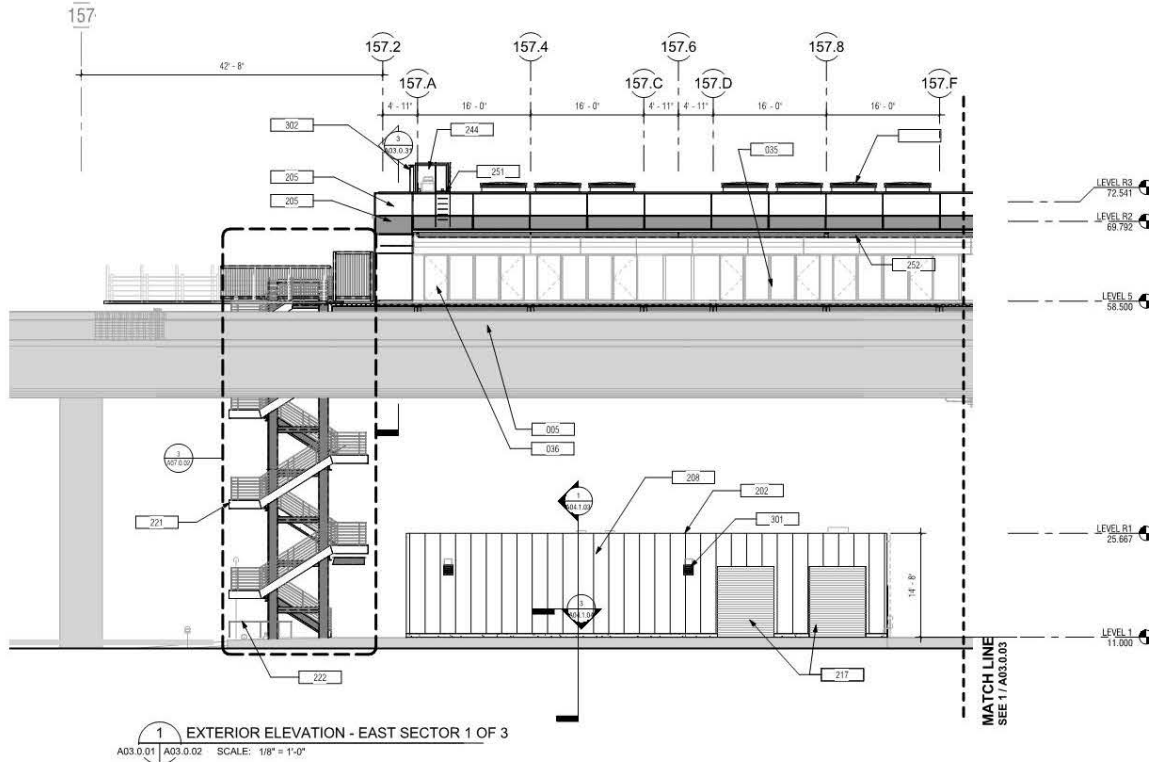

1 EXTERIOR ELEVATION - EAST SECTOR 1 OF 3  
A03.0.01 | A03.0.02 SCALE: 1/8" = 1'-0"

GENERAL SHEET NOTES

- REFER TO A10.0.03 AND A10.0.04 FOR WINDOW AND LOUVER SCHEDULES AND TYPES.

KEYNOTES	
Key	Keynote Text
005	EXIST CONC BENT FOOT
035	AUTOMATIC SLIDING DOOR, BY OTHERS
036	EED, BY OTHERS
086	
202	PRE-ENGINEERED METAL BUILDING
205	CURTAIN WALL GLAZING ASSY, TYP TOGGLE GLAZED (CW-1)
208	FIRE RATED INSULATED WALL PANEL
217	WEATHERSEALED OVERHEAD COILING DOOR, TYP
221	EXIT STAIR & GUARDRAIL, TYP CONCRETE PAN FILLED STEPS
222	2" DIA SST CANE RAIL BARRIER AT OVERHEAD HAZARD
244	ALUM ROOF ACCESS HATCH, 4' X 4' NOM
252	RAIL TYPE CABLE FALL RESTRAINT SYSTEM ATTACHED ON CANOPY
301	WALL LOUVER - SMD
302	DAWT CRANE W/ 500W ELEC WINCH, SED



San Francisco International Airport

**SKANSKA**  
1999 Harrison St., #1950  
Oakland, CA 94612  
skanska.com

**wsp**  
415 Market St.  
17th Fl.  
San Francisco, CA 94105  
wsp.com

**rc**  
Robert Chang & Company  
381 Valencia Street  
San Francisco, CA 94103  
(415) 398-2678

NO.	DATE	REVISIONS

10504.66

PROJECT FILE: SFO AIRTRAIN EXTENSION AND IMPROVEMENTS PROGRAM

SUBTITLE: LOT DD STATION EXTERIOR ELEVATION - EAST SHEET 1 OF 3

APPROVED: \_\_\_\_\_

APPROVED: \_\_\_\_\_

APPROVED: \_\_\_\_\_

DESIGNED BY: B. CHANG

DRAWN BY: M. REEVES

SCALE: AS SHOWN

SHEET NUMBER: 797-A03.0.02


CHECKED BY: J. ANDLUM

DATE: MARCH 23, 2018

SUB: REVISION (AMSD)

- GENERAL SHEET NOTES**
- REFER TO A10.0.03 AND A10.0.04 FOR WINDOW AND LOUVER SCHEDULES AND TYPES.

KEYNOTES	
Key Value	Keynote Text
035	AUTOMATIC SLIDING DOOR, BY OTHERS
202	PRE-ENGINEERED METAL BUILDING
205	CURTAIN WALL GLAZING ASSY, TYP 105/6L GLAZED (206-1)
208	FIRE RATED INSULATED WALL PANEL

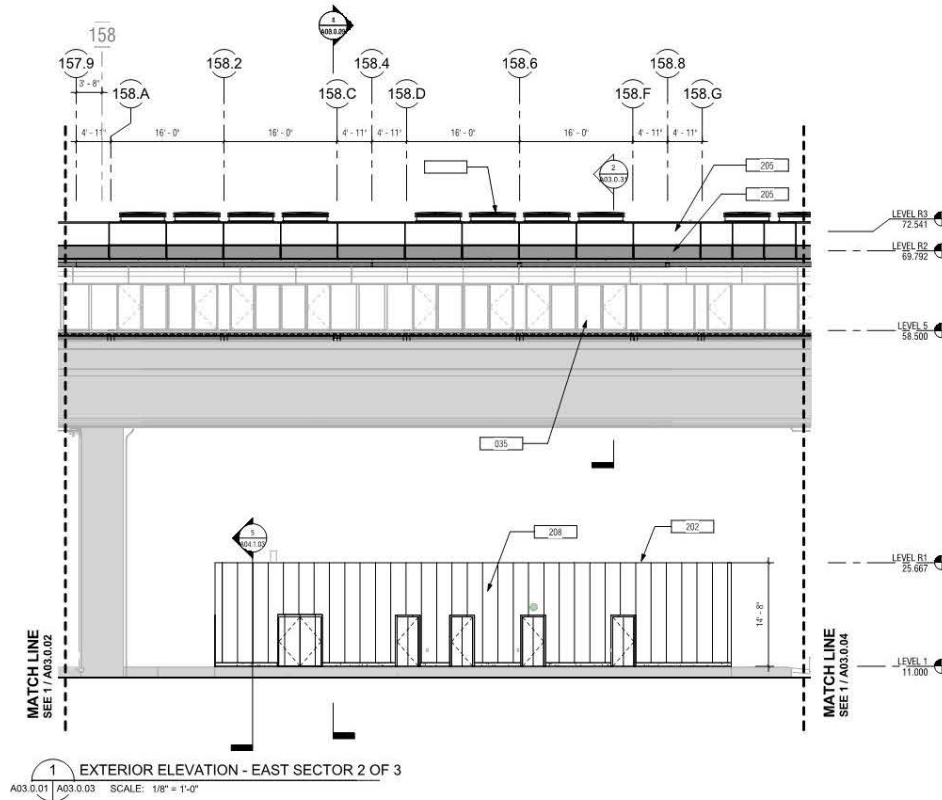

1 EXTERIOR ELEVATION - EAST SECTOR 2 OF 3  
A03.0.01 A03.0.03 SCALE: 1/8" = 1'-0"

**San Francisco International Airport**

1999 Harrison St., #1950  
Oakland, CA 94612  
skanska.com

425 Market St.  
San Francisco, CA 94102  
wsp.com

Rubin Chang & Company  
281 Tehama Street  
San Francisco, CA 94103  
(415) 995-9879

NO.	DATE	REVISIONS	BY

**10504.66**

**SFO AIRTRAIN EXTENSION AND IMPROVEMENTS PROGRAM**

**LOT DD STATION**

**EXTERIOR ELEVATION - EAST**

**SHEET 2 OF 3**

APPROVED: \_\_\_\_\_

APPROVED: \_\_\_\_\_


APPROVED: \_\_\_\_\_

DESIGNED BY: R. CHANG	CHECKED BY: J. ANGLIM
DRAWN BY: M. REEDS	DATE: MARCH 23, 2018
SCALE: AS NOTED	SIR: REVISION: [ ]
SHEET NUMBER: 797-A03.0.03	

Copyright © 2014-2015 City and County of San Francisco. These construction documents are the sole property of the City and County of San Francisco and are protected by the Copyright Act. Any reproduction, publication, or use in any method, in whole or in part, without the express written consent of the San Francisco Airport Commission is prohibited.

If this drawing is not A03.0 (34X27) NOMINAL SIZE, it has been revised from its original size and scales noted are no longer applicable.

100% CONSTRUCTION DOCUMENTS

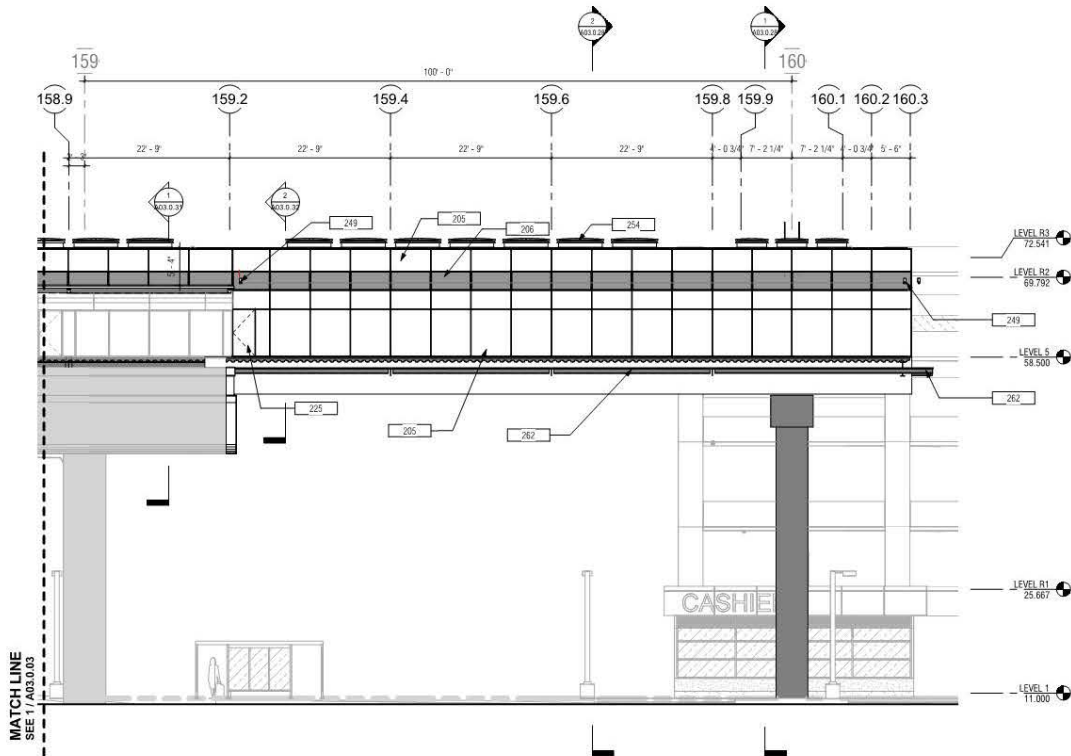

1 EXTERIOR ELEVATION - EAST SECTOR 3 OF 3  
A03.0.01 A03.0.04 SCALE: 1/8" = 1'-0"

GENERAL SHEET NOTES

- REFER TO A10.0.03 AND A10.0.04 FOR WINDOW AND LOUVER SCHEDULES AND TYPES.

KEYNOTES	
Key Value	Keynote Text
205	CURTAIN WALL GLAZING ASSY, TYP TOGGLE GLAZED (CW-1)
206	ALUMINUM LOUVER INFILL WITH CURTAIN GLASS WALL FRAME
225	MAINT ACCESS DOOR INTEGRATED IN CURTAIN WALL GLAZING ASSY
249	12 MM OVERHEAD CABLE FALL RESTRAINT SYSTEM
251	METAL STRAIGHT LADDER TO ROOFS
254	UL 793 LISTED SMOKE VENT WITH FIRE ALARM SYSTEM ELECTRICAL INTEGRATION
262	METAL CATWALK, 1 1/2" DEEP GRATING BOLTED TO STEEL BRACKET ASSEMBLY



San Francisco International Airport



1999 Harrison St. #1900  
Oakland, CA 94612  
skanska.com



475 Market St.  
17th Fl.  
San Francisco, CA 94106  
wsp.com



Robin Chang & Company  
381 Tahoma Street  
San Francisco, CA 94103  
(415) 995-9870

CONTRACT NO.	10504.66
PROJECT TITLE	SFO AIRTRAIN EXTENSION AND IMPROVEMENTS PROGRAM
SHEET TITLE	LOT DD STATION EXTERIOR ELEVATION - EAST SHEET 3 OF 3
DATE	
BY	
REVISIONS	

DESIGNED BY	R. CHANG	CHECKED BY	J. ANGLER
DRAWN BY	M. REYES	DATE	MARCH 23, 2018
SCALE	AS NOTED	SHEET NUMBER	797-A03.0.04

APPROVED:	
APPROVED:	
APPROVED:	


SCALE	1" = 10'-0"
DATE	MARCH 23, 2018
SHEET NUMBER	797-A03.0.04



GENERAL SHEET NOTES

- REFER TO A10 D 03 AND A10 D 04 FOR WINDOW AND LOUVER SCHEDULES AND TYPES.

KEYNOTES	
Key Value	Keynote Text
035	AUTOMATIC SLIDING DOOR, BY OTHERS
036	LED BY OTHERS
202	PRE-ENGINEERED METAL BUILDING
205	CURTAIN WALL GLAZING ASSY. TYP TOGGLE GLAZED (CW-1)
206	ALUMINUM LOUVER INFILL WITHIN CURTAIN GLASS WALL FRAME
208	FIRE RATED INSULATED WALL PANEL
221	EXIT STAIR & GUARDRAIL, TYP CONCRETE PAN FLEED STEPS
228	SSS FRAME & METAL PICKET FENCE ATTACHED TO EXTERIOR PLATFORM LANDING
254	UL 793 LISTED SMOKE VENT WITH FIRE ALARM SYSTEM ELECTRICAL INTEGRATION

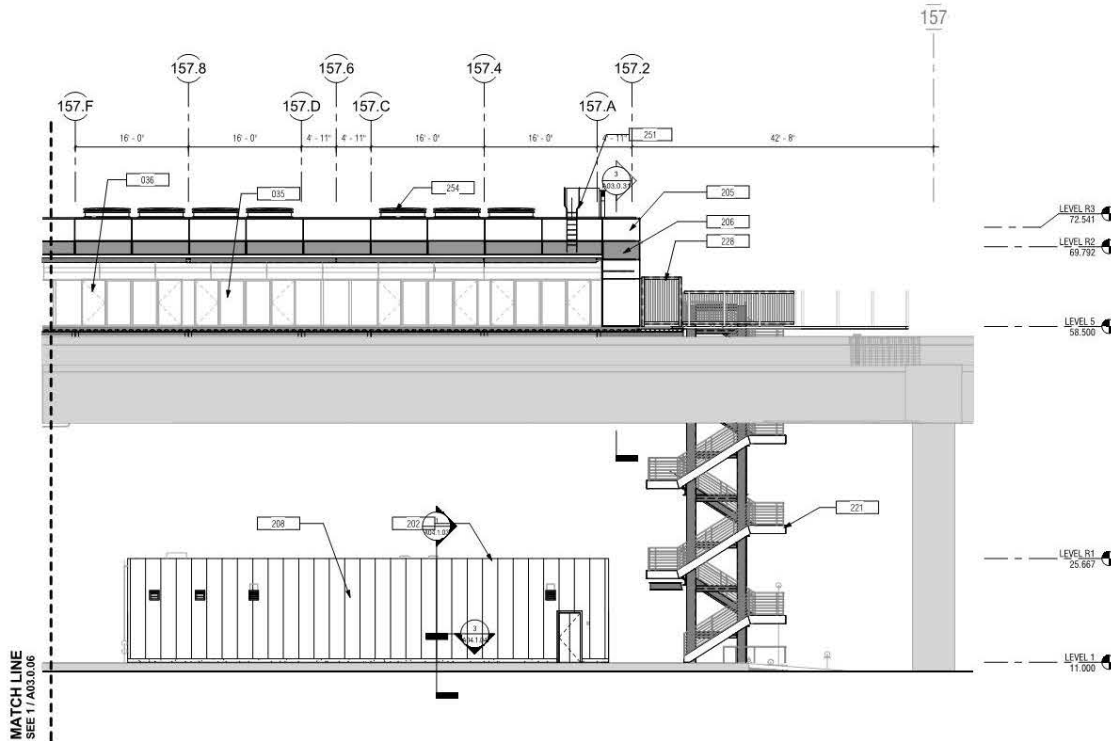

MATCH LINE  
SEE 17 A03.0.06

1 EXTERIOR ELEVATION - WEST SECTOR 1 OF 3  
A03.0.01 A03.0.05 SCALE: 1/8" = 1'-0"

**SKANSKA** 1999 Harrison St., #1950  
Oakland, CA 94612  
skanska.com

**wsp** 415 Market St.  
17th Fl.  
San Francisco, CA 94102  
wsp.com

**icc** Rubin Chang & Company  
2811 Marina Street  
San Francisco, CA 94103  
(415) 695-9879

CONTRACT NO. 10504.66

PROJECT TITLE  
**SFO AIRTRAIN EXTENSION AND IMPROVEMENTS PROGRAM**

SHEET TITLE  
**LOT DD STATION EXTERIOR ELEVATION - WEST SHEET 1 OF 3**

NO. DATE REVISIONS

SCALE: 1" = 16'-0"

APPROVED: \_\_\_\_\_


APPROVED: \_\_\_\_\_

DESIGNED BY: R. CHANG CHECKED BY: J. ANGLIM

DRAWN BY: M. REEDER DATE: MARCH 23, 2018

SCALE: AS NOTED SDR: REVISION: ANS(0)

SHEET NUMBER: 797-A03.0.05

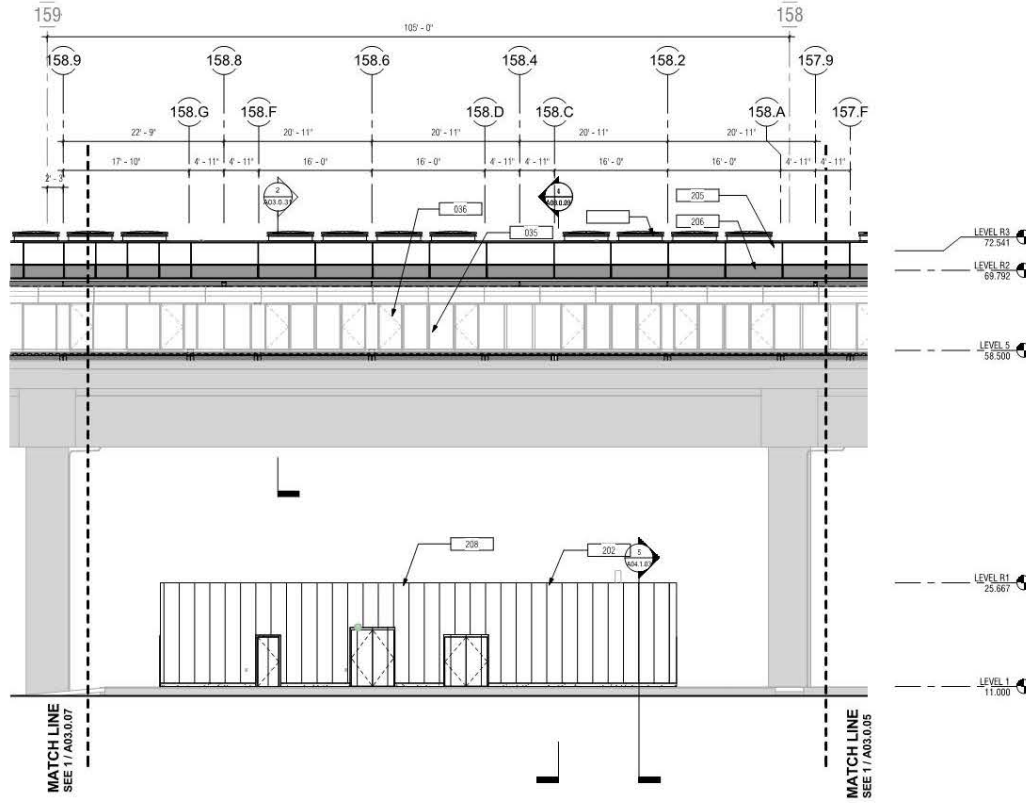

1 EXTERIOR ELEVATION - WEST SECTOR 2 OF 3  
A03.0.01 | A03.0.06 SCALE: 1/8" = 1'-0"

- GENERAL SHEET NOTES**
- REFER TO A10.0.03 AND A10.0.04 FOR WINDOW AND LOUVER SCHEDULES AND TYPES.

KEYNOTES	
Key	Value
	Keynote Text
035	AUTOMATIC SLIDING DOOR, BY OTHERS
036	FED. BY OTHERS
202	PRE-ENGINEERED METAL BUILDING
205	CURTAIN WALL GLAZING ASSY, TYP-TOGGLE (GLAZED CUR-1)
206	ALUMINUM LOUVER INFILL WITHIN CURTAIN GLASS WALL FRAME
208	FIRE RATED INSULATED WALL PANEL



San Francisco International Airport

**SKANSKA** 1999 Harrison St., #1900  
Oakland, CA 94612  
skanska.com

**wsp** 425 Market St.  
17th Fl.  
San Francisco, CA 94105  
wsp.com

**RC** Rubin Chany & Company  
381 Valencia Street  
San Francisco, CA 94103  
(415) 995-9819

NO.	DATE	BY	REVISIONS

**10504.66**

PROJECT TITLE  
**SFO AIRTRAIN EXTENSION AND IMPROVEMENTS PROGRAM**

SHEET TITLE  
**LOT DD STATION EXTERIOR ELEVATION - WEST SHEET 2 OF 3**




APPROVED:	CHECKED BY:
APPROVED:	DATE:
DESIGNED BY:	DATE:
DRAWN BY:	DATE:
SCALE:	REVISION:
SHEET NUMBER:	REVISION:

797-A03.0.06

GENERAL SHEET NOTES

- REFER TO A10 0.03 AND A10 0.04 FOR WINDOW AND LOUVER SCHEDULES AND TYPES.

KEYNOTES	
Key Value	Keynote Text
201	PREFINISHED EXT ALUM WALL PANEL (MP-1)
225	MAINT ACCESS DOOR INTEGRATED IN CURTAIN WALL GLAZING ASSY
249	12 MM OVERHEAD CABLE FALL RESTRAINT SYSTEM
251	METAL STRAIGHT LADDER TO ROOFS
262	METAL CATWALK 1 1/2" DEEP GRATING BOLTED TO STEEL BRACKET ASSEMBLY
263	STEEL DIAGONAL BRACING, SSD
277	FIRE RATED DOORS ON MAGNETIC HOLD OPEN

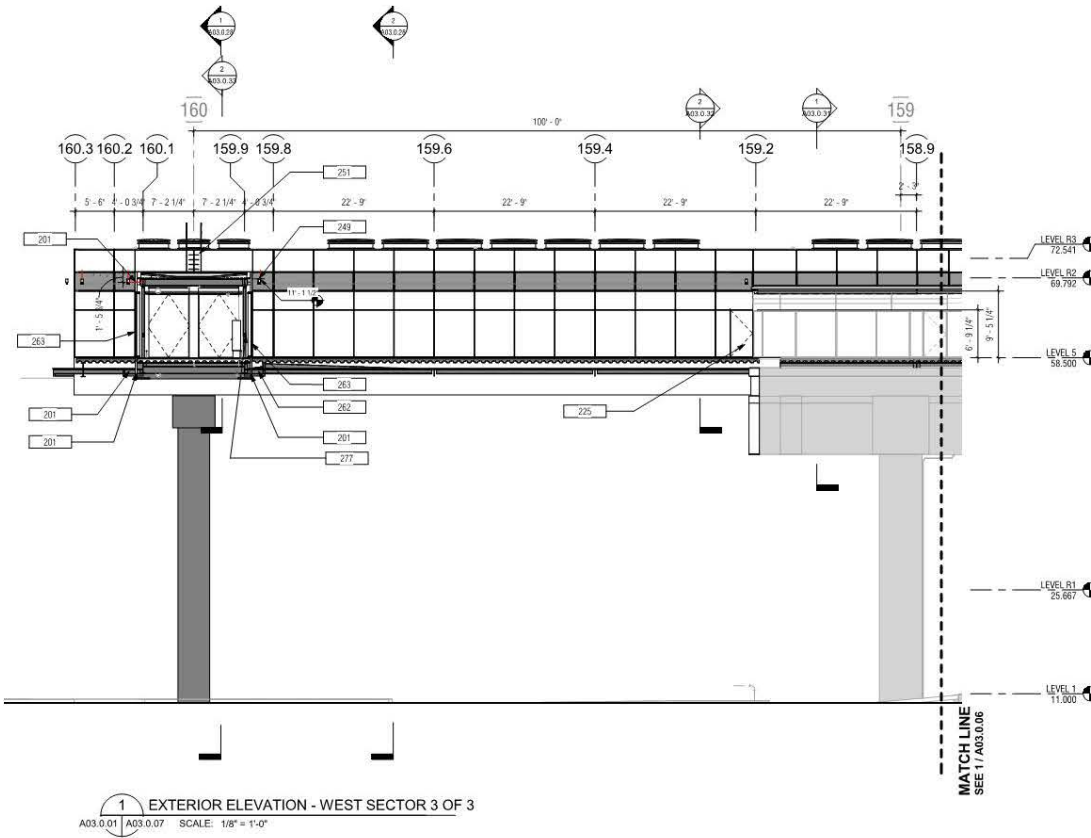

**SKANSKA** 1999 Harrison St. #1950  
Oakland, CA 94612  
skanska.com

**WSP** 415 Market St.  
7th Fl.  
San Francisco, CA 94105  
wsp.com

**FC&C** Fisher Chang & Company  
3811 Laguna Street  
San Francisco, CA 94103  
(415) 695-9879

NO.	DATE	REVISIONS

CONTRACT NO. **10504.66**

PROJECT FILE **SFO AIRTRAIN EXTENSION AND IMPROVEMENTS PROGRAM**

SHEET FILE **LOT DD STATION EXTERIOR ELEVATION - WEST SHEET 3 OF 3**

SCALE: 1/8" = 1'-0"

APPROVED: \_\_\_\_\_


APPROVED: \_\_\_\_\_

APPROVED: \_\_\_\_\_

DESIGNED BY: R. CHANG  
DRAWN BY: W. REYES  
SCALE: AS NOTED  
SHEET NUMBER: 797-A03.0.07

CHECKED BY: J. ANDERSON  
DATE: MARCH 23, 2018  
NO. 1  
REVISION  
797-A03.0.07



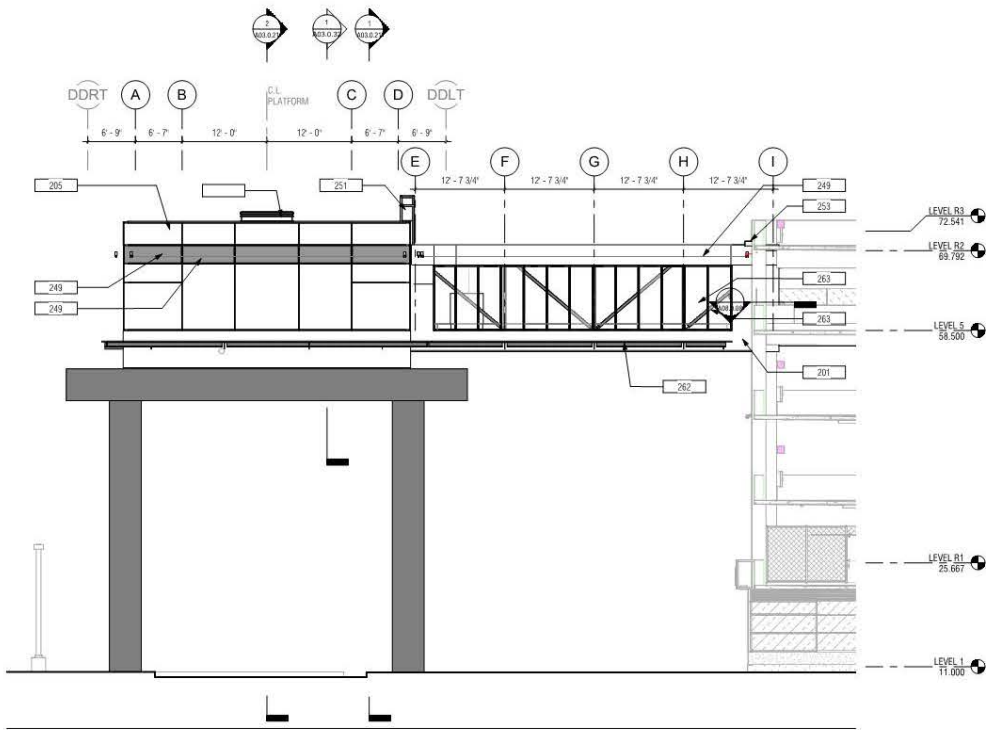

1 EXTERIOR ELEVATION - NORTH  
A03.0.08 SCALE: 1/8" = 1'-0"

**GENERAL SHEET NOTES**  
1. REFER TO A10.0.03 AND A10.0.04 FOR WINDOW AND LOUVER SCHEDULES AND TYPES.

KEYNOTES	
Key Value	Keynote Text
201	PREFINISHED EXT ALUM WALL PANEL (MP-1)
205	CURTAIN WALL GLAZING ASSY. TYP TOGGLE GLAZED (CW-1)
249	12 MM OVERHEAD CABLE FALL RESTRAINT SYSTEM
251	METAL STRAIGHT LADDER TO ROOFS
253	BRACKET METAL COVER @ PEDESTRIAN BRIDGE ROOF ATTACHED TO PARKING STRUCTURE
262	METAL CATWALK 1 1/2" DEEP GRATING BOLTED TO STEEL BRACKET ASSEMBLY
263	STEEL DIAGONAL BRACING. SSD

**San Francisco International Airport**

1999 Harrison St. #1900  
Oakland, CA 94612  
skanska.com

415 Market St.  
7th Fl.  
San Francisco, CA 94105  
wsp.com

Rohm Chang & Company  
2811 Veterans Blvd  
San Francisco, CA 94103  
(415) 695-9879

NO.	DATE	REVISIONS

**10504.66**

**PROJECT TITLE**  
SFO AIRTRAIN EXTENSION AND IMPROVEMENTS PROGRAM

**SHEET TITLE**  
LOT DD STATION EXTERIOR ELEVATION - NORTH

APPROVED: \_\_\_\_\_

APPROVED: \_\_\_\_\_


APPROVED: \_\_\_\_\_

DESIGNED BY: R. CHANG	CHECKED BY: J. ANGLIM
DRAWN BY: M. REEVES	DATE: MARCH 23, 2018
SCALE: AS SHOWN	SUR. REGION: ANSI-0

SHEET NUMBER:  
797-A03.0.08

1" = 12' 0"

100% CONSTRUCTION DOCUMENTS

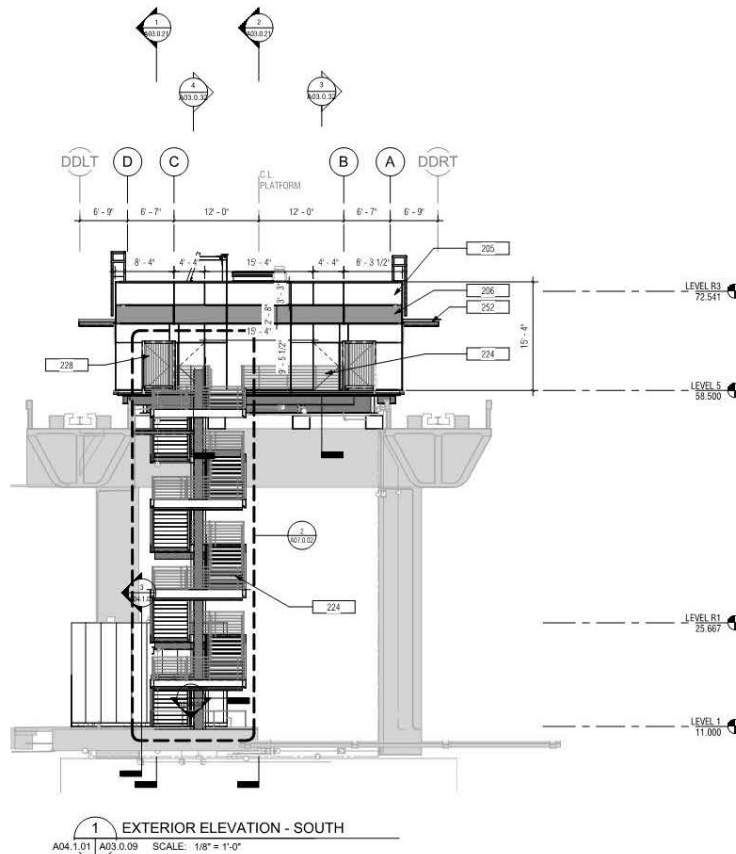

**GENERAL SHEET NOTES**

- REFER TO A10.0.03 AND A10.0.04 FOR WINDOW AND LOUVER SCHEDULES AND TYPES.

KEYNOTES	
Key Value	Keynote Text
255	CURTAIN WALL GLAZING ASSY, TYP. TOGGLE GLAZED (CW-1)
256	ALUMINUM LOUVER INFILL WITH CURTAIN GLASS WALL FRAME
224	42" GALV PIPE GUARDRAIL, TYP (P-2)
228	HSS FRAME & METAL PICKET FENCE ATTACHED TO EXTERIOR PLATFORM LANDING
257	RAIL TYPE CABLE FALL RESTRAINT SYSTEM ATTACHED ON CANOPY

**San Francisco International Airport**

1999 Harrison St., #1950  
Oakland, CA 94612  
skanska.com

415 Market St.  
7th Fl.  
San Francisco, CA 94105  
wsp.com

Rubin Chang & Company  
281 Toland Street  
San Francisco, CA 94103  
(415) 695-9879

NO.	DATE	REVISIONS

**10504.66**

**PROJECT TITLE**  
SFO AIRTRAIN EXTENSION AND IMPROVEMENTS PROGRAM

**SHEET TITLE**  
LOT DD STATION  
EXTERIOR ELEVATION - SOUTH

APPROVED: \_\_\_\_\_

APPROVED: \_\_\_\_\_

APPROVED: \_\_\_\_\_

DESIGNED BY: R. CHANG	CHECKED BY: J. ANGLIM
DRAWN BY: M. REYES	DATE: MARCH 23, 2018
SCALE: AS NOTED	JOB / REGION: ANS-0
SHEET NUMBER: 797-A03.0.09	

1" = 12' 0"

APPROVED: \_\_\_\_\_

APPROVED: \_\_\_\_\_

APPROVED: \_\_\_\_\_

DESIGNED BY: R. CHANG      CHECKED BY: J. ANGLIM

DRAWN BY: M. REYES      DATE: MARCH 23, 2018

SCALE: AS NOTED      JOB / REGION: ANS-0

SHEET NUMBER: 797-A03.0.09


Copyright © 2014-2015 City And County Of San Francisco. These construction documents are the sole property of The City And County Of San Francisco and are protected by the Copyright Act. Any reproduction, publication, or use by any method, in whole or in part, without the express written consent of the San Francisco Airport Commission is prohibited.

If this drawing is not ANSI D (34"x22") NOMINAL SIZE, it has been revised from its original size and scales noted are no longer applicable.


100% CONSTRUCTION DOCUMENTS



San Francisco International Airport

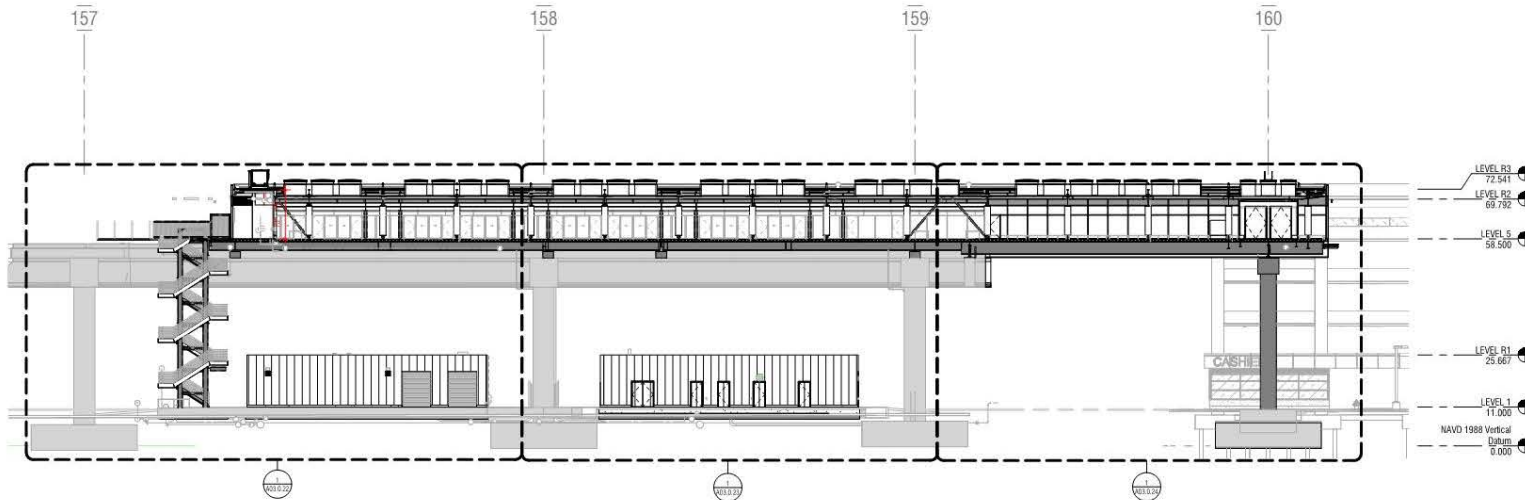

2 OVERALL LONGITUDINAL SECTION - CENTERLINE  
 A02.5.01 | A03.0.21 SCALE: 1/16" = 1'-0"

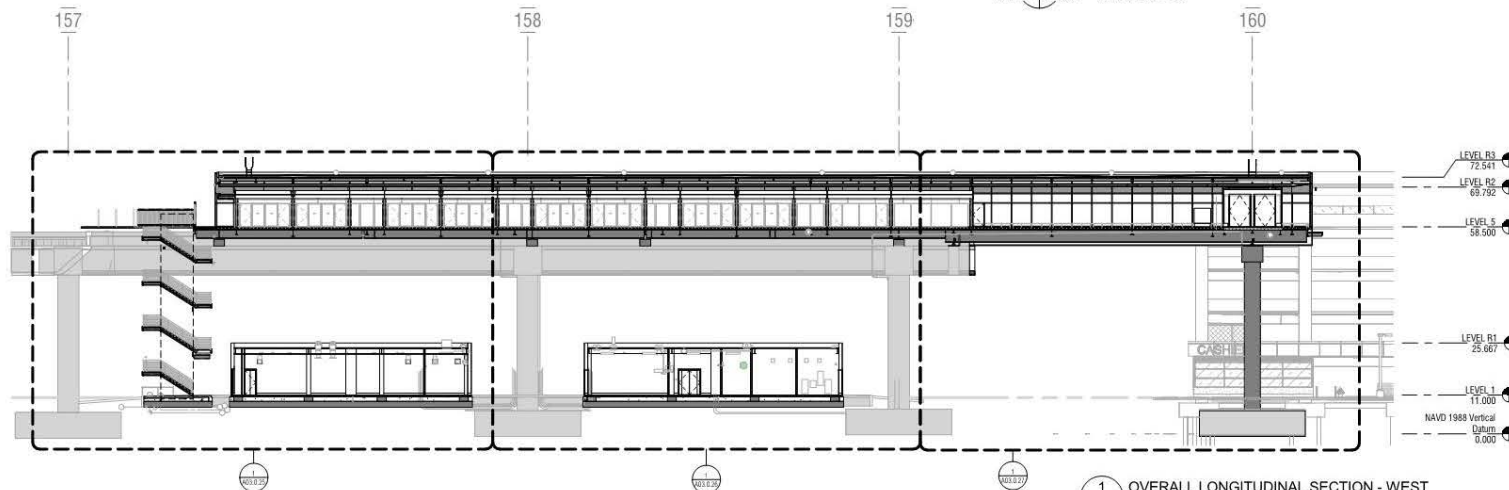

1 OVERALL LONGITUDINAL SECTION - WEST  
 A02.5.01 | A03.0.21 SCALE: 1/16" = 1'-0"

San Francisco International Airport


**SKANSKA** 1999 Harrison St. #1950  
Oakland, CA 94612  
skanska.com

**WSP** 415 Market St.  
7th Fl.  
San Francisco, CA 94105  
wsp.com

**FC** Fisher Chang & Company  
3811 Toluca Street  
San Francisco, CA 94103  
(415) 995-9879

10504.66	<b>10504.66</b> PROJECT TITLE <b>SFO AIRTRAIN EXTENSION AND IMPROVEMENTS PROGRAM</b>	SHEET TITLE <b>LOT DD STATION OVERALL LONGITUDINAL SECTIONS</b>
CONTRACT NO. SCALE APPROVED: APPROVED: APPROVED: DESIGNED BY: R. CHANG DRAWN BY: M. REYES SCALE: AS NOTED SHEET NUMBER: 797-A03.0.21		
CHECKED BY: J. ANDRUS DATE: MARCH 23, 2018 SOU: REVISOR:		
© 2018 San Francisco International Airport Authority. All rights reserved.		



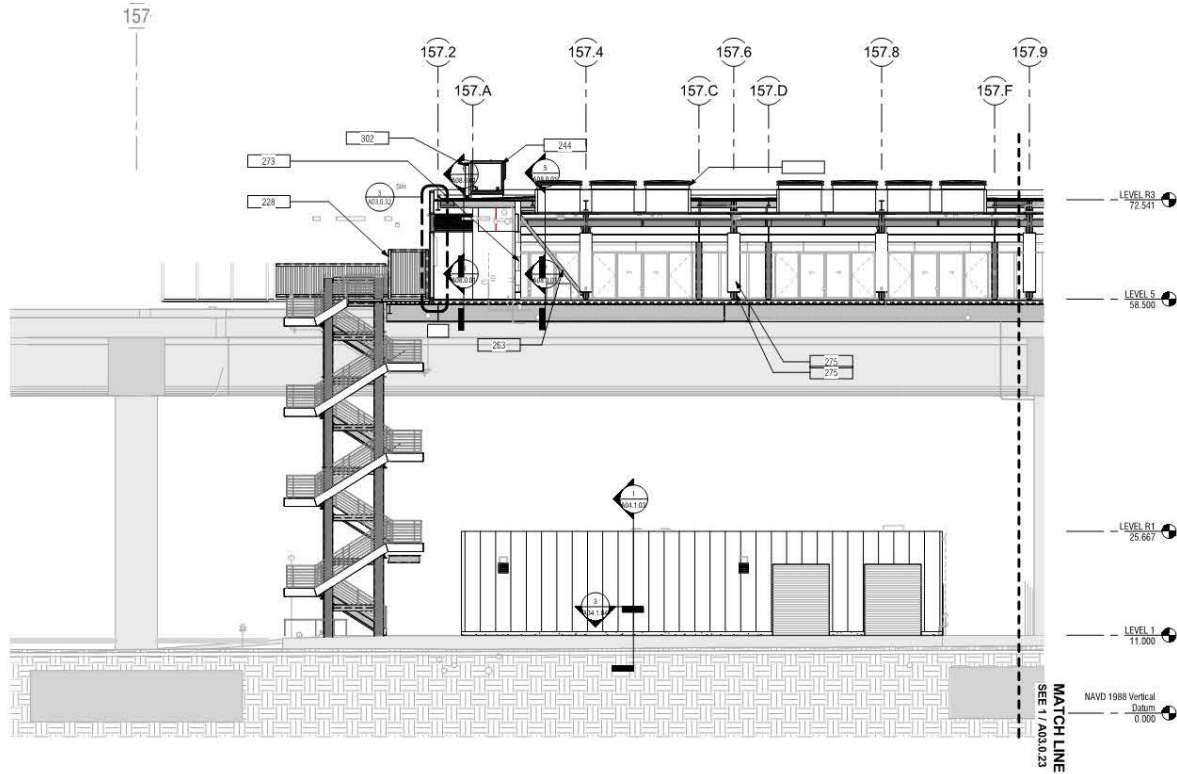

1 LONGITUDINAL SECTION - CENTERLINE SECTOR 1 OF 3  
A03.0.21 A03.0.22 SCALE: 1/8" = 1'-0"

GENERAL SHEET NOTES

KEYNOTES	
Key Value	Keynote Text
228	SSS FRAME & METAL PICKET FENCE ATTACHED TO EXTERIOR PLATFORM LANDING.
244	ALUM ROOF ACCESS HATCH: 4' X 4' NOM
263	STEEL DIAGONAL BRACING, SSD
273	PORCELAIN WALL TILE AND BACKER BOARD (W/T-2)
275	12" TALL 16GA SST BASE, TYP (ST-1)
302	DAVIT CRANE W/ 500# ELEC WINCH, SSD



San Francisco International Airport

**SKANSKA** 1699 Harrison St. #1950  
Oakland, CA 94612  
skanska.com

**WSP** 415 Market St  
7th Fl  
San Francisco, CA 94105  
wsp.com

**FCG** Fisher Consulting & Company  
3811 Laguna Street  
San Francisco, CA 94103  
(415) 995-9879

NO.	DATE	REVISIONS

10504.66

PROJECT TITLE  
**SFO AIRTRAIN EXTENSION AND IMPROVEMENTS PROGRAM**

SHEET TITLE  
**LONGITUDINAL SECTION - CENTERLINE SHEET 1 OF 3**

LOT DD STATION


SCALE

0 10' 20' 30'

APPROVED:	APPROVED:
APPROVED:	APPROVED:
DESIGNED BY: R. CHANG	CHECKED BY: J. ANDERSON
DRAWN BY: M. REYES	DATE: MARCH 23, 2018
SCALE: AS NOTED	SHEET REVISION: AS SHOWN
SHEET NUMBER: 797-A03.0.22	

GENERAL SHEET NOTES

KEYNOTES	
Key Value	Keynote Text

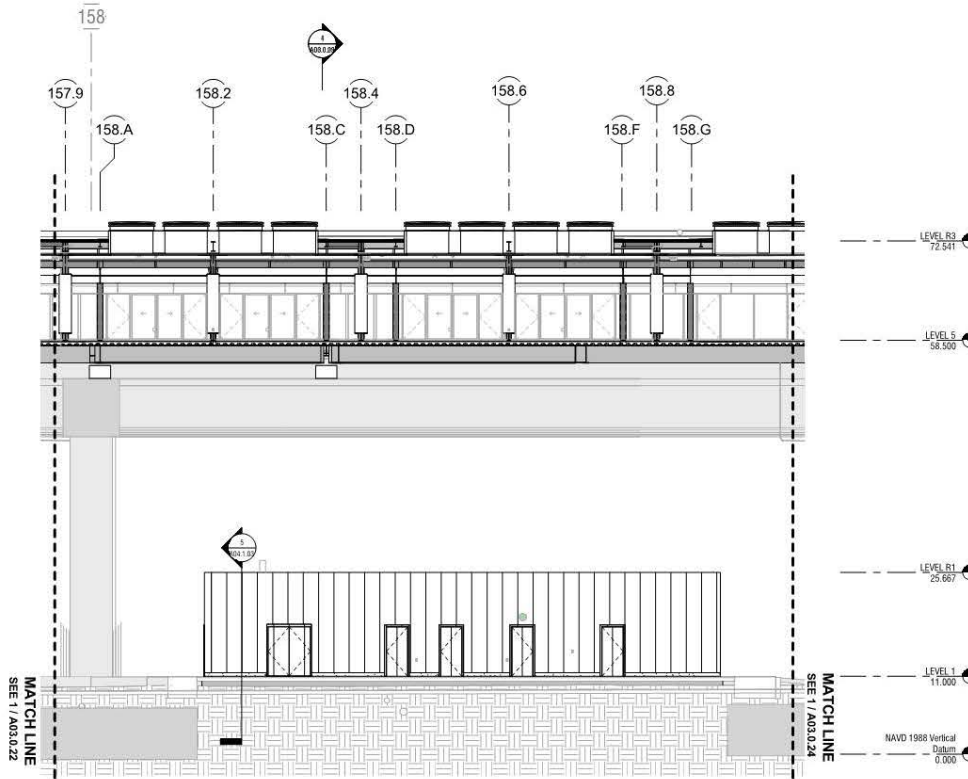

1 LONGITUDINAL SECTION - CENTERLINE SECTOR 2 OF 3  
A03.0.21 A03.0.23 SCALE: 1/8" = 1'-0"



San Francisco International Airport


**SKANSKA** 1999 Harrison St., #1950  
Oakland, CA 94612  
skanska.com

**wsp** 425 Market St.  
17th Fl.  
San Francisco, CA 94105  
wsp.com


**RCB** Rubin Chang & Company  
381 Valencia Street  
San Francisco, CA 94103  
(415) 595-8878

CONTRACT NO.	10504.66
PROJECT FILE	SFO AIRTRAIN EXTENSION AND IMPROVEMENTS PROGRAM
SHEET TITLE	LONGITUDINAL SECTION - CENTERLINE SHEET 2 OF 3
REV.	REVISIONS
DATE	

APPROVED:	
APPROVED:	
APPROVED:	
DESIGNED BY:	J. CHANG
DRAWN BY:	M. REEVES
SCALE:	AS NOTED
CHECKED BY:	J. ANGLIM
DATE:	MARCH 23, 2018
NO.	REVISION
SHEET NUMBER:	797-A03.0.23

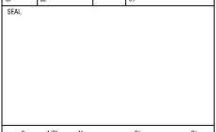

APPROVED:	
APPROVED:	
APPROVED:	
DESIGNED BY:	J. CHANG
DRAWN BY:	M. REEVES
SCALE:	AS NOTED
CHECKED BY:	J. ANGLIM
DATE:	MARCH 23, 2018
NO.	REVISION
SHEET NUMBER:	797-A03.0.23

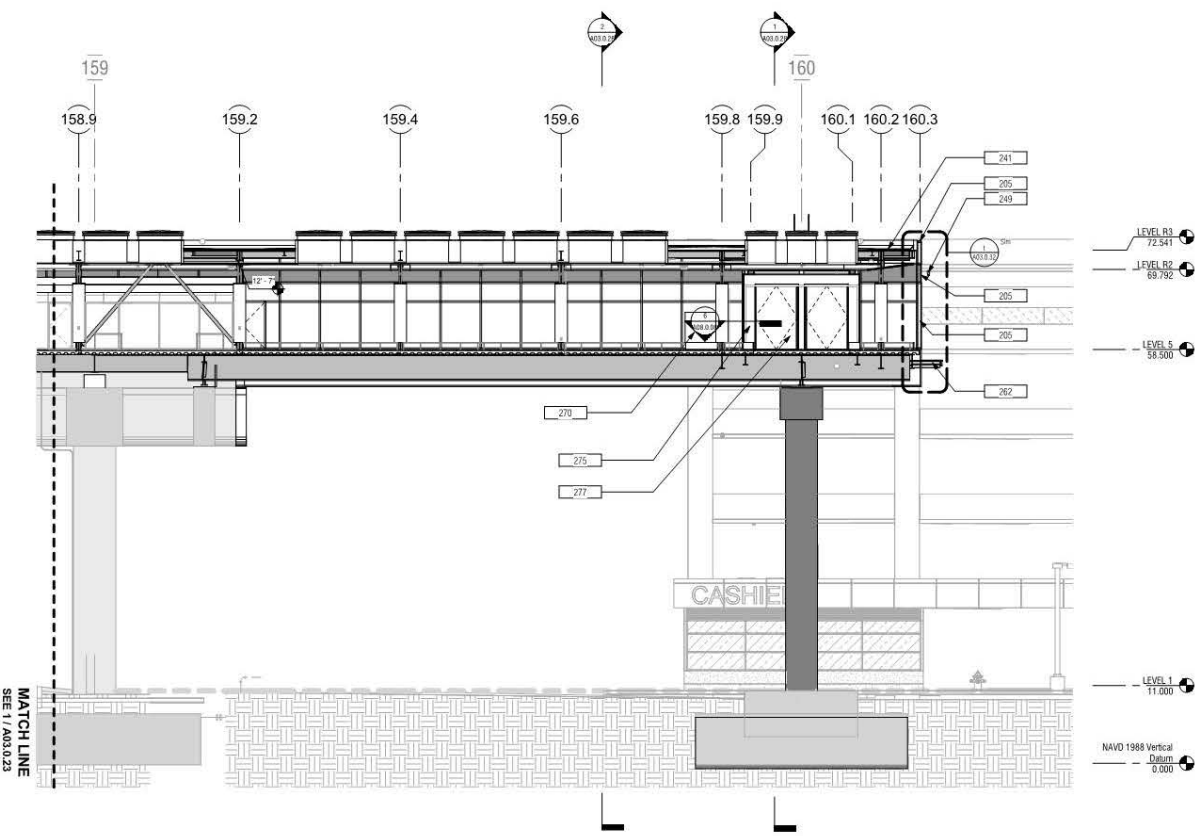

**1** LONGITUDINAL SECTION - CENTERLINE SECTOR 3 OF 3  
A03.0.21 | A03.0.24 SCALE: 1/8" = 1'-0"

**GENERAL SHEET NOTES**

Key	Keynote Text
205	CURTAIN WALL GLAZING ASSY, TYP TOGGLE GLAZED (CW-1)
241	SINGLE PLY MEMBRANE ROOF ASSY
249	12 MM OVERHEAD CABLE FALL RESTRAINT SYSTEM
262	METAL CATWALK 1 1/2" DEEP GRATING BOLTED TO STEEL BRACKET ASSEMBLY
270	STANDPIPE CABINET, STAINLESS STEEL #4 FINISH
275	12" TALL 16GA SST BASE, TYP (ST-1)
277	FIRE RATED DOORS ON MAGNETIC HOLD DPEN



**San Francisco International Airport**

**SKANSKA** 1999 Harrison St. #1950  
Oakland, CA 94612  
skanska.com

**WSP** 415 Market St.  
7th Fl.  
San Francisco, CA 94105  
wsp.com

**FC** Rubin Chang & Company  
381 Tolman Street  
San Francisco, CA 94103  
(415) 995-9879


NO.	DATE	REVISIONS

**10504.66**

PROJECT FILE: **SFO AIRTRAIN EXTENSION AND IMPROVEMENTS PROGRAM**

SHEET FILE: **LOT DD STATION**


**LONGITUDINAL SECTION - CENTERLINE SHEET 3 OF 3**

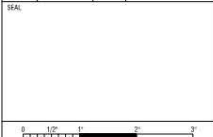

APPROVED:	APPROVED:
DESIGNED BY: R. CHANG	CHECKED BY: J. ANDERSON
DRAWN BY: W. REYES	DATE: MARCH 23, 2018
SCALE: AS NOTED	SHEET NUMBER: 797-A03.0.24

GENERAL SHEET NOTES

KEYNOTES	
Key Value	Keynote Text
202	PRE-ENGINEERED METAL BUILDING
205	CURTAIN WALL GLAZING ASSY, TYP TOGGLE GLAZED (CW-1)
221	EXIT STAIR & GUARDRAIL, TYP CONCRETE PANELLED STEPS
241	SINGLE-PLY MEMBRANE ROOF ASSY
242	PREFINISHED ALUM CORING, TYP

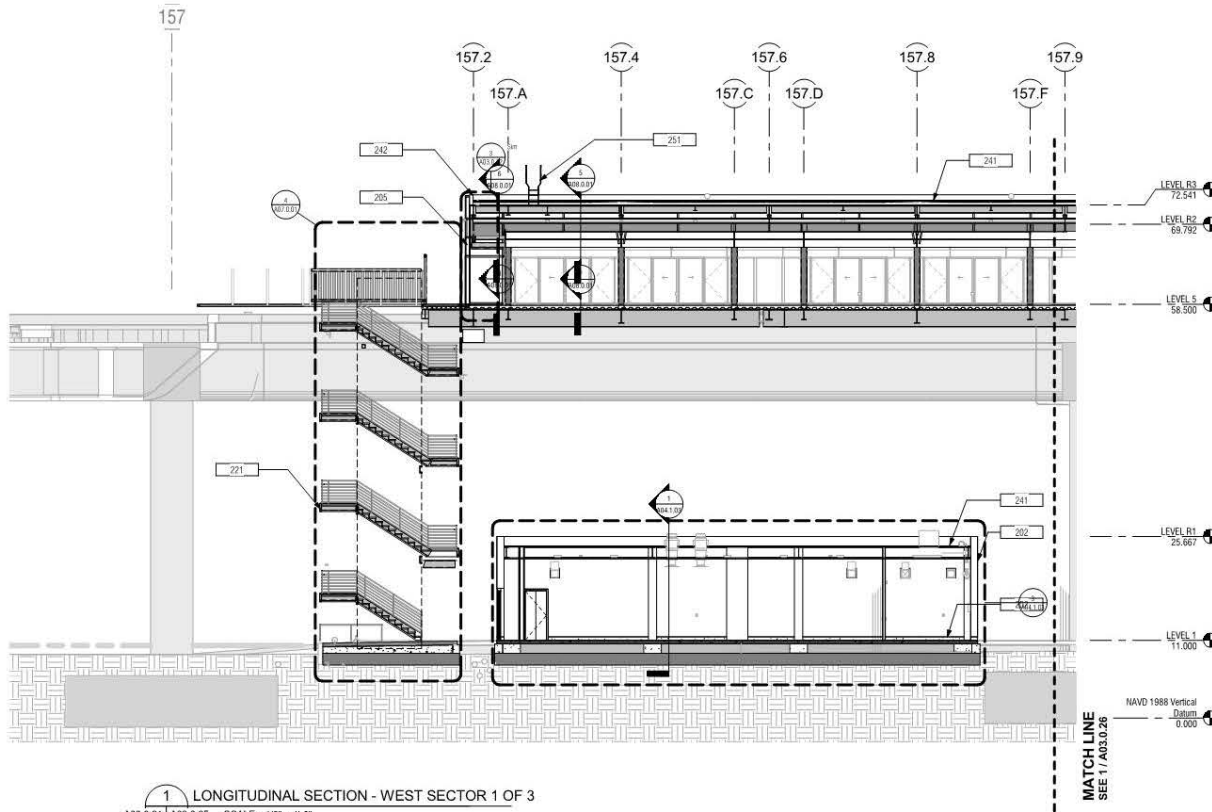

1 LONGITUDINAL SECTION - WEST SECTOR 1 OF 3  
A03.0.21 | A03.0.25 SCALE: 1/8" = 1'-0"

SKANSKA

1999 Harrison St. #1950  
Oakland, CA 94612  
skanska.com

WSP

415 Market St  
7th Fl  
San Francisco, CA 94105  
wsp.com

FC

Robin Chiang & Company  
3811 Teahena Street  
San Francisco, CA 94103  
(415) 895-9879

10504.66

PROJECT FILE  
SFO AIRTRAIN EXTENSION AND  
IMPROVEMENTS PROGRAM

SHEET FILE  
LONGITUDINAL SECTION - WEST  
LOT DD STATION  
SHEET 1 OF 3

CONTRACT NO.

SCALE


APPROVED:	APPROVED:	APPROVED:
DESIGNED BY: R. CHANG	CHECKED BY: J. ANDERSON	DATE: MARCH 23, 2018
DRAWN BY: M. REYES	DATE:	SCALE: AS NOTED
SHEET NUMBER: 797-A03.0.25	NO.:	REVISION: AS SHOWN

100% CONSTRUCTION DOCUMENTS



GENERAL SHEET NOTES

KEYNOTES	
Key Value	Keynote Text
202	PRE-ENGINEERED METAL BUILDING
241	SINGLE-PLY MEMBRANE ROOF ASSY
257	PRE-MANUFACTURED METAL ROOF ON CONCRETE FILLED METAL DECK ASSEMBLY
259	CONCRETE SLAB @ UTILITY ROOMS (CONC-3)

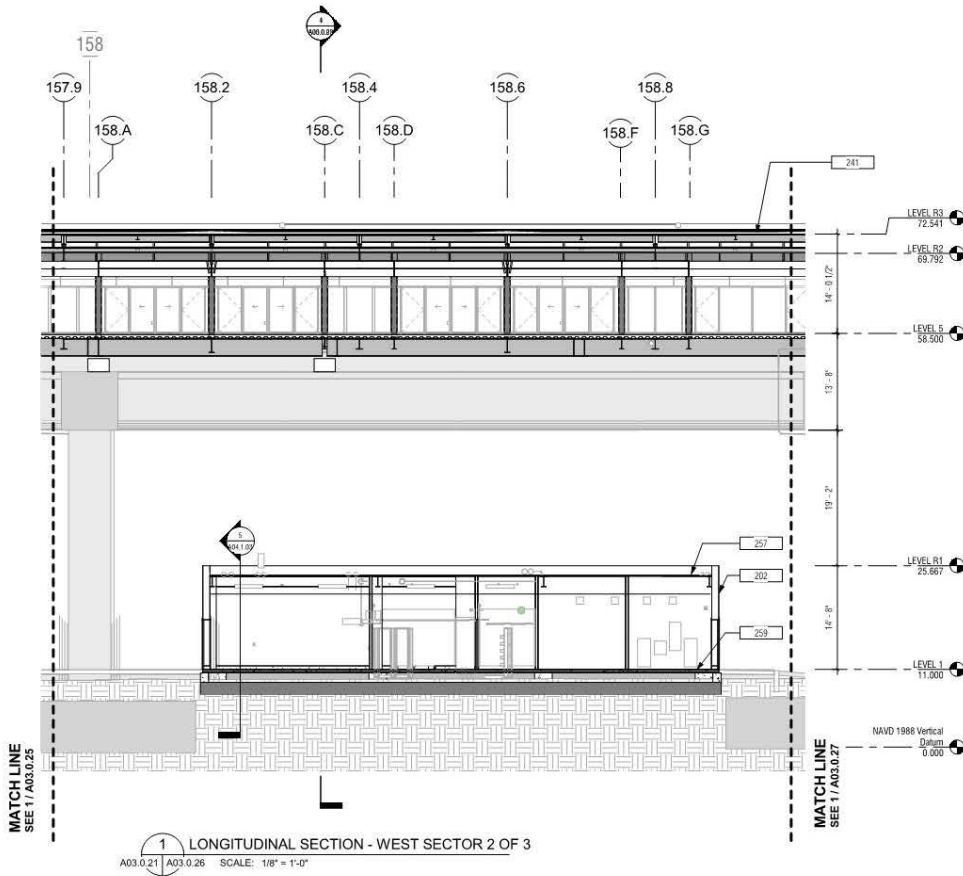

San Francisco International Airport

**SKANSKA**  
1999 Harrison St., #1950  
Oakland, CA 94612  
skanska.com

**wsp**  
425 Market St.  
17th Fl.  
San Francisco, CA 94105  
wsp.com


**RCB**  
Robert Chang & Company  
281 Valencia Street  
San Francisco, CA 94103  
(415) 595-8878

NO.	DATE	REVISIONS

CONTRACT NO. **10504.66**

PROJECT TITLE **SFO AIRTRAIN EXTENSION AND IMPROVEMENTS PROGRAM**


SHEET TITLE **LONGITUDINAL SECTION - WEST LOT DD STATION SHEET 2 OF 3**

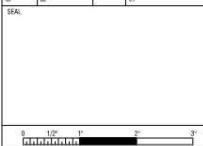

APPROVED:	DESIGNED BY: <b>R. CHANG</b>	CHECKED BY: <b>J. ANGLIM</b>
APPROVED:	DRAWN BY: <b>M. REEVES</b>	DATE: <b>MARCH 23, 2018</b>
APPROVED:	SCALE: <b>AS NOTED</b>	SUB. REVISION: <b>(NONE)</b>
SHEET NUMBER: <b>797-A03.0.26</b>		

GENERAL SHEET NOTES

Key Value	Keynote Text
202	PRE-ENGINEERED METAL BUILDING
205	CURTAIN WALL GLAZING ASSY, TYP FOOTGLE GLAZED (CW-1)
225	MAINT ACCESS DOOR INTEGRATED IN CURTAIN WALL GLAZING ASSY
241	SINGLE-PLY MEMBRANE ROOF ASSY
249	12" MM OVERHEAD CABLE FALL RESTRAINT SYSTEM
251	METAL STRAIGHT LADDER TO ROOFS
257	PRE-MANUFACTURED METAL ROOF ON CONCRETE FILLED METAL DECK ASSEMBLY
259	CONCRETE SLAB @ UTILITY ROOMS (CONC-3)
262	METAL CATHANK 1 1/2" DEEP GRATING BOLTED TO STEEL BRACKET ASSEMBLY
266	SLOPED CEILING PREFINISHED PERFORATED ALUM CEILING PANELS
270	STAINLESS CUPBOARD, STAINLESS STEEL #4 FINISH

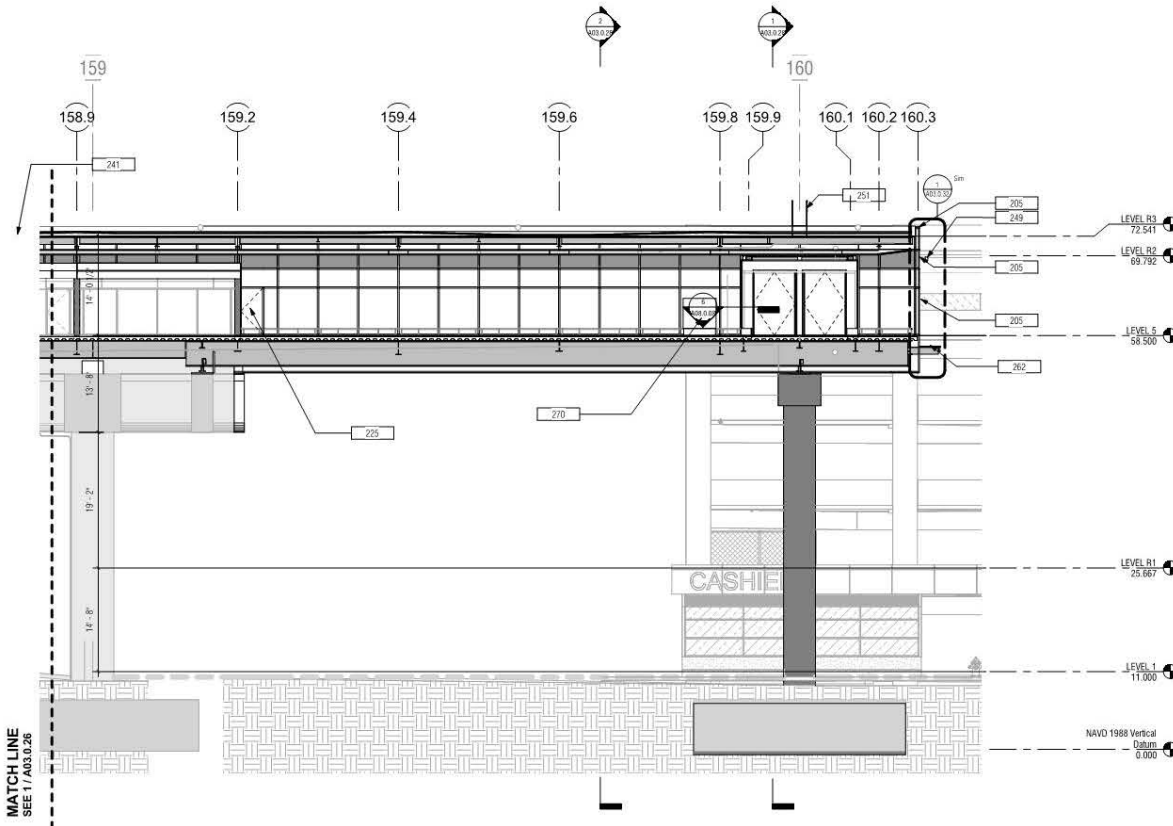

1 LONGITUDINAL SECTION - WEST SECTOR 3 OF 3  
A03.0.21 A03.0.27 SCALE: 1/8" = 1'-0"

NO.	DATE	REVISIONS

10504.66


PROJECT FILE  
**SFO AIRTRAIN EXTENSION AND IMPROVEMENTS PROGRAM**

SHEET FILE  
**LONGITUDINAL SECTION - WEST SHEET 3 OF 3**


CONTRACT NO.  
SCALE

APPROVED:	APPROVED:
APPROVED:	APPROVED:
DESIGNED BY: R. CHANG	CHECKED BY: J. ANDERSON
DRAWN BY: M. REYES	DATE: MARCH 23, 2018
SCALE: AS NOTED	SHEET NUMBER: 797-A03.0.27

KEYNOTES	
Key Value	Keynote Text
201	PREFINISHED EXT ALUM WALL PANEL (WP-1)
205	CURTAIN WALL GLAZING ASSY, TYP TOGGLE GLAZED (CW-1)
241	SINGLE-PLY MEMBRANE ROOF ASSY
249	12 MM OVERHEAD CABLE FALL RESTRAINT SYSTEM
262	METAL CATWALK 1 1/2" DEEP GRATING BOLTED TO STEEL BRACKET ASSEMBLY
272	PREFINISHED PERFORATED ALUM CEILING PANELS
275	12" TALL 16GA SST BASE, TYP (ST-1)
276	2" DIA FLOOR MTD SST GUARD - 12" AFF, TYP

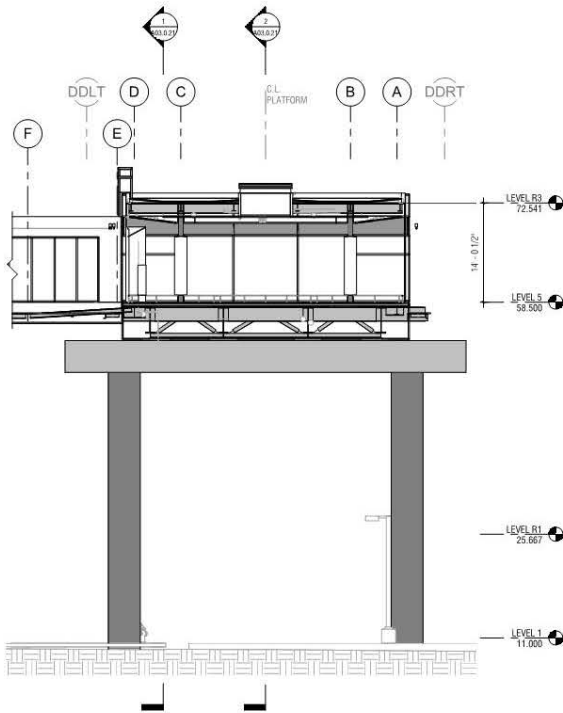

2 TRANSVERSE SECTION - C  
A02.5.03 | A03.0.28 SCALE: 1/8" = 1'-0"

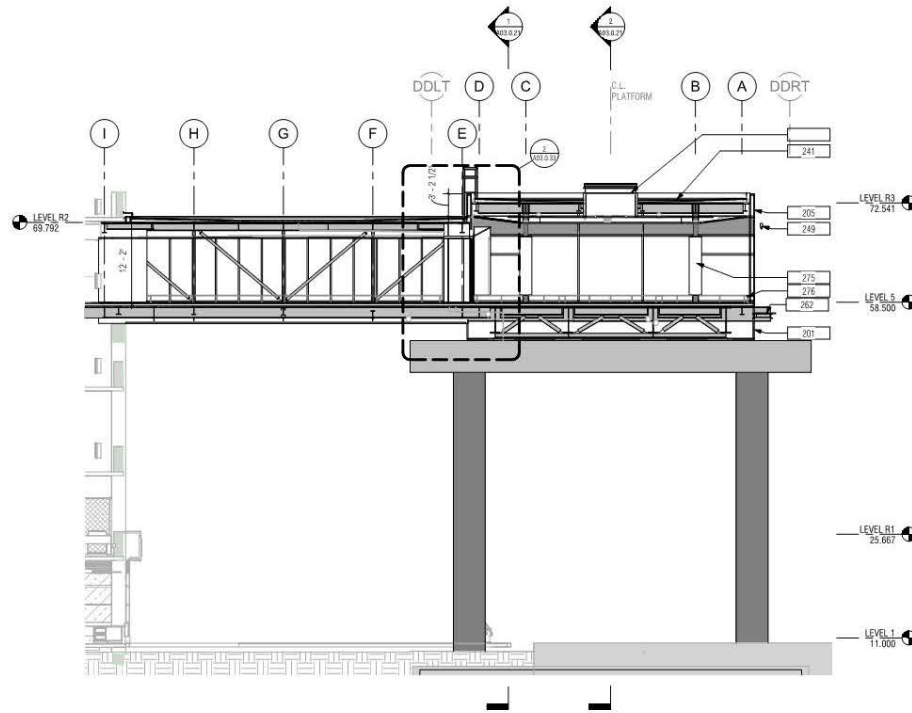

1 TRANSVERSE SECTION - D  
A02.5.03 | A03.0.28 SCALE: 1/8" = 1'-0"



**SKANSKA** 1999 Harrison St., #1950  
Oakland, CA 94612  
skanska.com

**wsp** 415 Market St.  
7th Fl.  
San Francisco, CA 94102  
wsp.com

**rcg** Rubin Chang & Company  
2811 Marina Street  
San Francisco, CA 94103  
(415) 695-9879

NO.	DATE	REVISIONS


10504.66

PROJECT TITLE  
**SFO AIRTRAIN EXTENSION AND IMPROVEMENTS PROGRAM**


SHEET TITLE  
**LOT DD STATION TRANSVERSE SECTIONS SHEET 1 OF 2**



APPROVED:	APPROVED:
DESIGNED BY: R. CHANG	CHECKED BY: J. ANGLIM
DRAWN BY: M. REEDER	DATE: MARCH 23, 2018
SCALE: AS NOTED	SIR / REVISION: [ ]
SHEET NUMBER 797-A03.0.28	

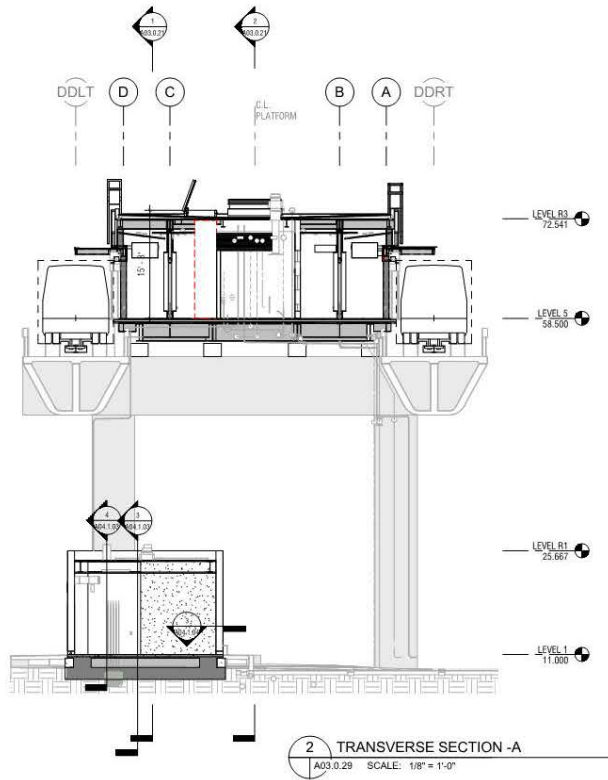

2 TRANSVERSE SECTION - A  
A03.0.29 SCALE: 1/8" = 1'-0"

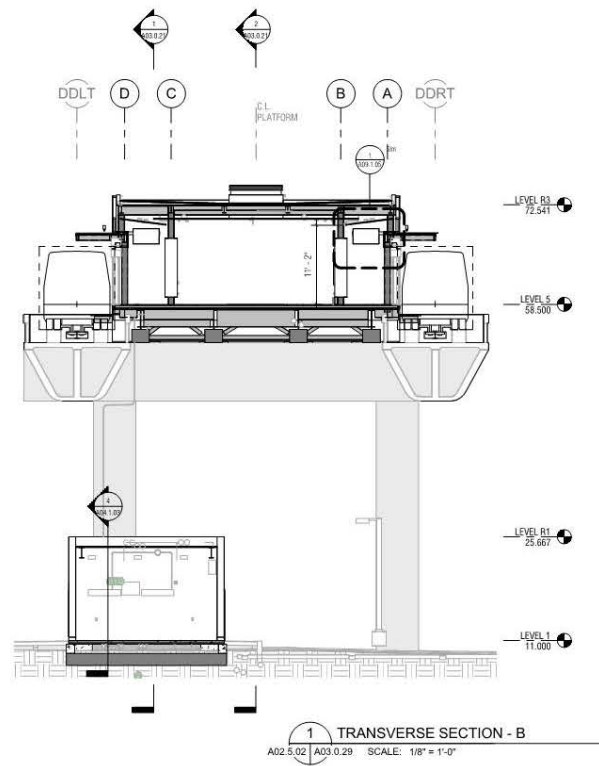

1 TRANSVERSE SECTION - B  
A02.5.02 A03.0.29 SCALE: 1/8" = 1'-0"

10504.66

CONTRACT NO.

SCALE

PROJECT TITLE  
SFO AIRTRAIN EXTENSION AND  
IMPROVEMENTS PROGRAM

SHEET TITLE  
LOT DD STATION

TRANSVERSE SECTIONS  
SHEET 2 OF 2




APPROVED:	
APPROVED:	
DESIGNED BY: R. CHANAY	CHECKED BY: J. BUCKLEW
DRAWN BY: M. REEVES	DATE: MARCH 23, 2018
SCALE: AS NOTED	SHEET REVISION (NONE)
SHEET NUMBER 797-A03.0.29	

B:\sfo\10504\10504\_66\_A03\_029.dwg



KEYNOTES	
Key Value	Keynote Text
082	
205	CURTAIN WALL GLAZING ASSY, TYP TOGGLE GLAZED (CW-1)
241	ENVELOPE-PLY MEMBRANE ROOF ASSY
261	CONCRETE TOPPING SLAB, BROOM FINISH (CONC-1)
266	SLOPED CEILING PREFINISHED PERFORATED ALUM CEILING PANELS

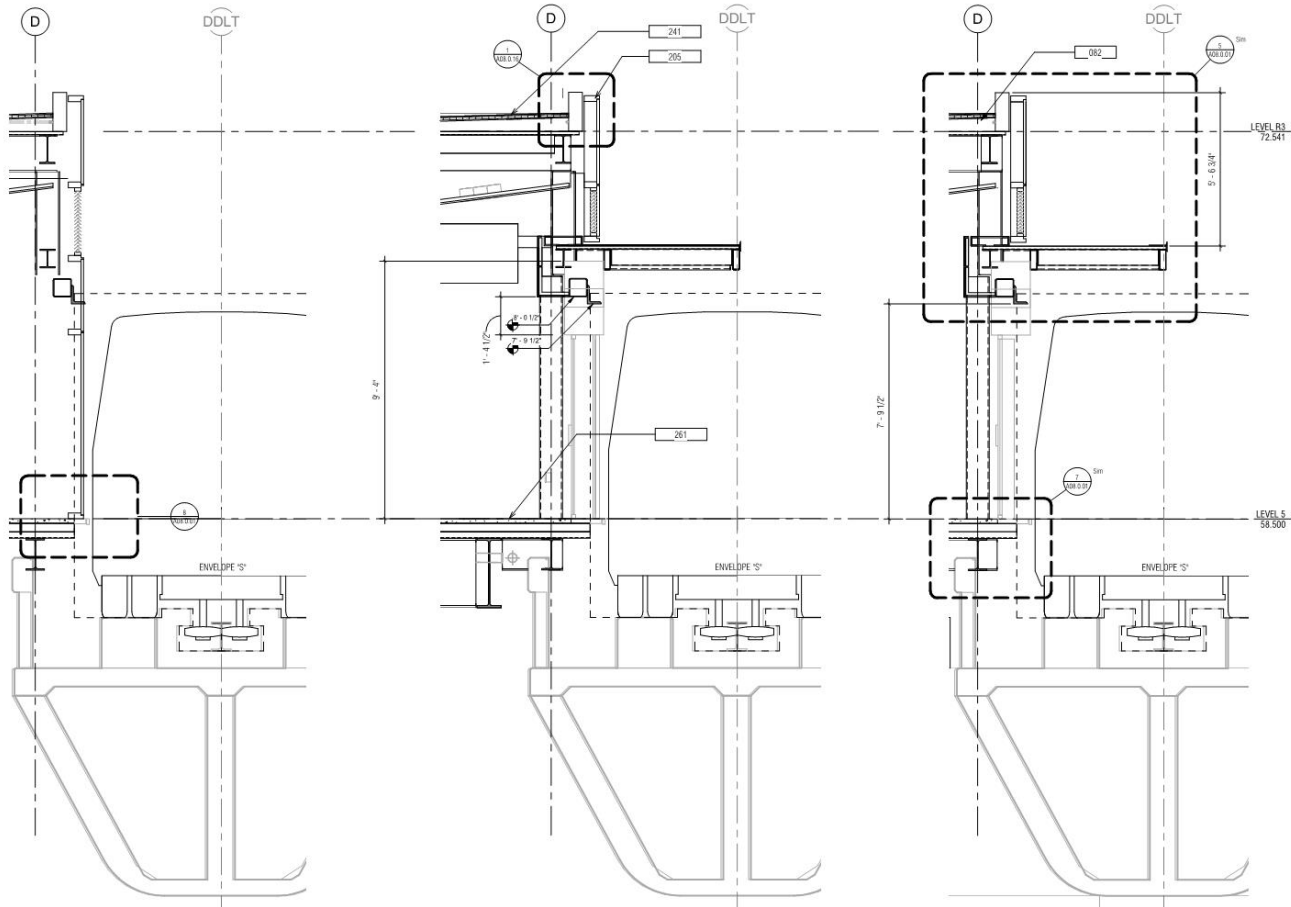

3 CURTAINWALL SECTION - SOUTH OF BARRIER WALL  
A03.0.02 A03.0.31 SCALE: 1/2" = 1'-0"

2 BARRIER WALL SECTION AT EDGE  
A03.0.03 A03.0.31 SCALE: 1/2" = 1'-0"

1 BARRIER WALL SECTION AT FIXED PANEL  
A03.0.04 A03.0.31 SCALE: 1/2" = 1'-0"

**San Francisco International Airport**

---

1999 Harrison St., #1800  
Oakland, CA 94612  
skanska.com

475 Market St.  
7th Fl.  
San Francisco, CA 94105  
wsp.com

---

Rubin Chandy & Company  
281 Leavenworth Street  
San Francisco, CA 94103  
(415) 995-9810

Revision Description	BY
DATE	REVISIONS

---

**10504.66**

**SFO AIRTRAIN EXTENSION AND IMPROVEMENTS PROGRAM**

**LOT DD STATION**

**WALL SECTIONS SHEET 1 OF 3**

CONTRACT NO.

PROJECT FILE

SHEET TITLE

SCALE

DATE

AS NOTED

SHEET NUMBER

---

APPROVED: \_\_\_\_\_

APPROVED: \_\_\_\_\_

APPROVED: \_\_\_\_\_

DESIGNED BY: B. CHANG

DRAWN BY: M. REEVES

CHECKED BY: J. ANGLIM

DATE: MARCH 23, 2018

FILE: T-TRUCKDRIVE

ANSID

---

0 1" = 0'-0"

0 2" = 0'-0"


797-A03.0.31

100% CONSTRUCTION DOCUMENTS



GENERAL SHEET NOTES

KEYNOTES	
Key Value	Keynote Text
201	REFINISHED EXT ALUM WALL PANEL (MP-1)
205	CURTAIN WALL GLAZING ASSY, TYP TOGGLE GLAZED (CW-1)
223	EXT CONC LANDING (S-1)
224	42" GALV PIPE GUARDRAIL, TYP (P-2)
249	12 MM OVERHEAD CABLE FALL RESTRAINT SYSTEM
262	METAL CATWALK 1 1/2" DEEP GRATING BOLTED TO STEEL BRACKET ASSEMBLY
273	PORCELAIN WALL TILE AND BACKER BOARD (WT-2)

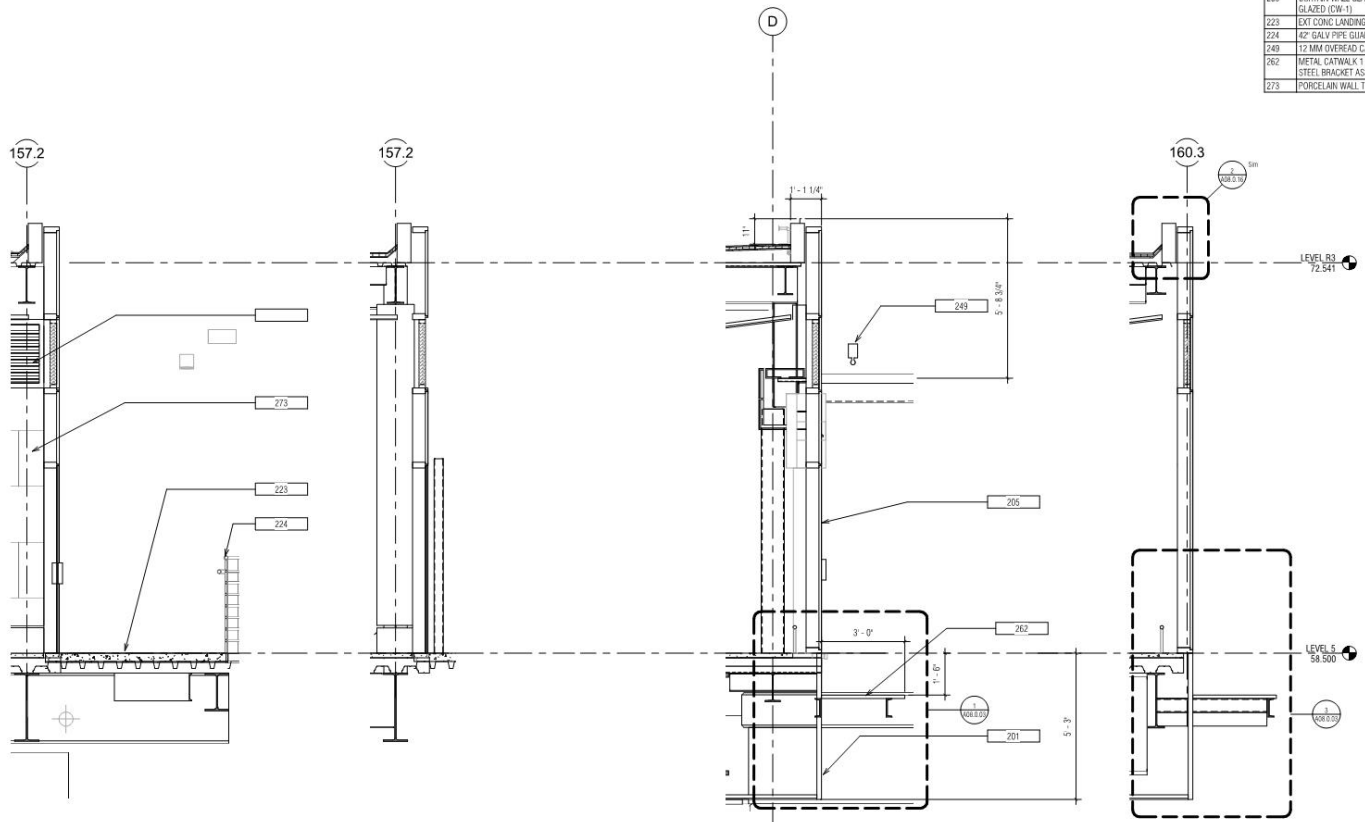

4 CURTAINWALL SECTION - DOOR PANEL SCALE: 1/2" = 1'-0"  
 3 CURTAINWALL SECTION - SOUTH END WALL TYP SCALE: 1/2" = 1'-0"  
 2 CURTAINWALL SECTION - LONGITUDINAL WALL TYP SCALE: 1/2" = 1'-0"  
 1 CURTAINWALL SECTION - NORTH ENDWALL SCALE: 1/2" = 1'-0"

San Francisco International Airport

1999 Harrison St. #1950  
Oakland, CA 94612  
skanska.com

478 Market St.  
17th Fl.  
San Francisco, CA 94105  
wsp.com

Roth Chang & Company  
381 Valencia Street  
San Francisco, CA 94103  
(415) 995-9873

NO.	REVISION

CONTRACT NO. 10504.66

PROJECT TITLE SFO AIRTRAIN EXTENSION AND IMPROVEMENTS PROGRAM

LOT DD STATION

SHEET TITLE WALL SECTIONS SHEET 2 OF 3

DESIGNED BY: J. ANJUM

CHECKED BY: J. ANJUM

DESIGN BY: M. REEVES

DATE: MARCH 23, 2016

SCALE: AS NOTED


PROJECT: 10504.66

SHEET NUMBER: ANSD

797-A03.0.32

GENERAL SHEET NOTES


KEYNOTES	
Key Value	Keynote Text

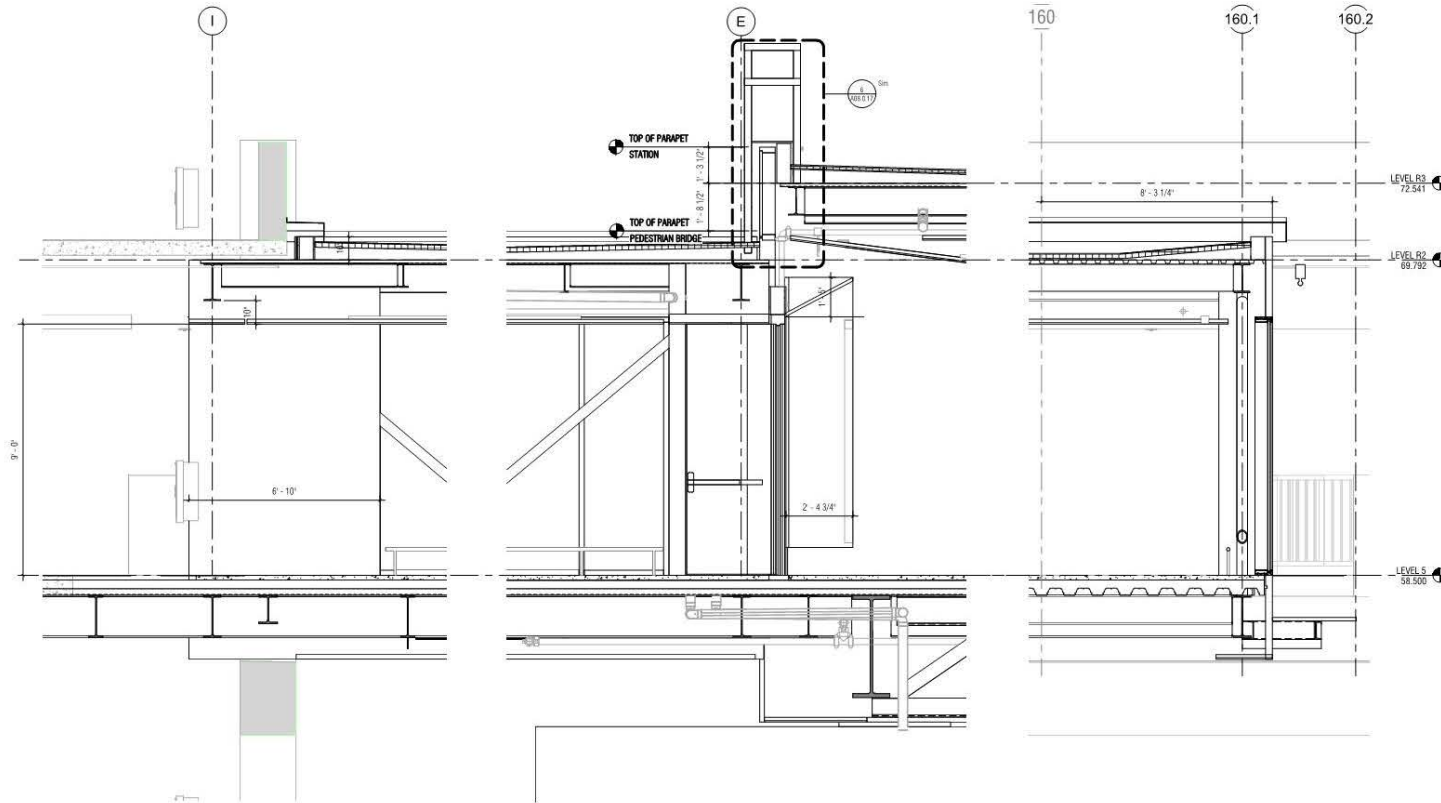




**3** CONNECTOR BRIDGE AT GARAGE  
A05.5.03 A03.0.33 SCALE: 1/2" = 1'-0"

**2** CONNECTOR BRIDGE AT PLATFORM  
A03.0.07 A03.0.33 SCALE: 1/2" = 1'-0"

**1** CONNECTOR BRIDGE - TRANSVERSE SECTION  
A04.5.11 A03.0.33 SCALE: 1/2" = 1'-0"



**San Francisco International Airport**

1999 Harrison St. #1900  
Oakland, CA 94612  
skanska.com

425 Market St.  
17th Fl.  
San Francisco, CA 94105  
wsp.com

Rohde Chancy & Company  
381 Tubman Street  
San Francisco, CA 94103  
(415) 956-9878

NO.	DATE	REVISION DESCRIPTION	BY

**10504.66**

**SFO AIRTRAIN EXTENSION AND IMPROVEMENTS PROGRAM**

**LOT DD STATION**

**WALL SECTIONS**

**SHEET 3 OF 3**

CONTRACT NO.

PROJECT TITLE

SHEET TITLE

SCALE

APPROVED: \_\_\_\_\_

DESIGNED BY: R. CHANGS

DRAWN BY: M. REEVES

SCALE: AS NOTED

SHEET NUMBER: 797-A03.0.33

CHECKED BY: J. ANSELMI

DATE: MARCH 23, 2018

SCALE: 1/8" = 1'-0"

ANSI D

SFO

San Francisco  
International  
Airport

# Thank You!

